

- Water Bottle Refill Station
- Standard Water Fountain




DWG. NO.:	REVISION DATE:
A-I	05-03-2018
	SCALE: NTS
	DESIGN BY:
BLDG. CODE:	PLA
CP	CHECKED BY: JCD

RECORD FLOOR PLAN
CHESAPEAKE HALL BUILDING

FIRST FLOOR PLAN

SALISBURY UNIVERSITY
 FACILITIES PLANNING & CAPITAL PROJECTS
 ARCHITECTURAL AND ENGINEERING SERVICES
 1101 CAMDEN AVENUE
 SALISBURY, MARYLAND 21801
 410 - 543 - 6215

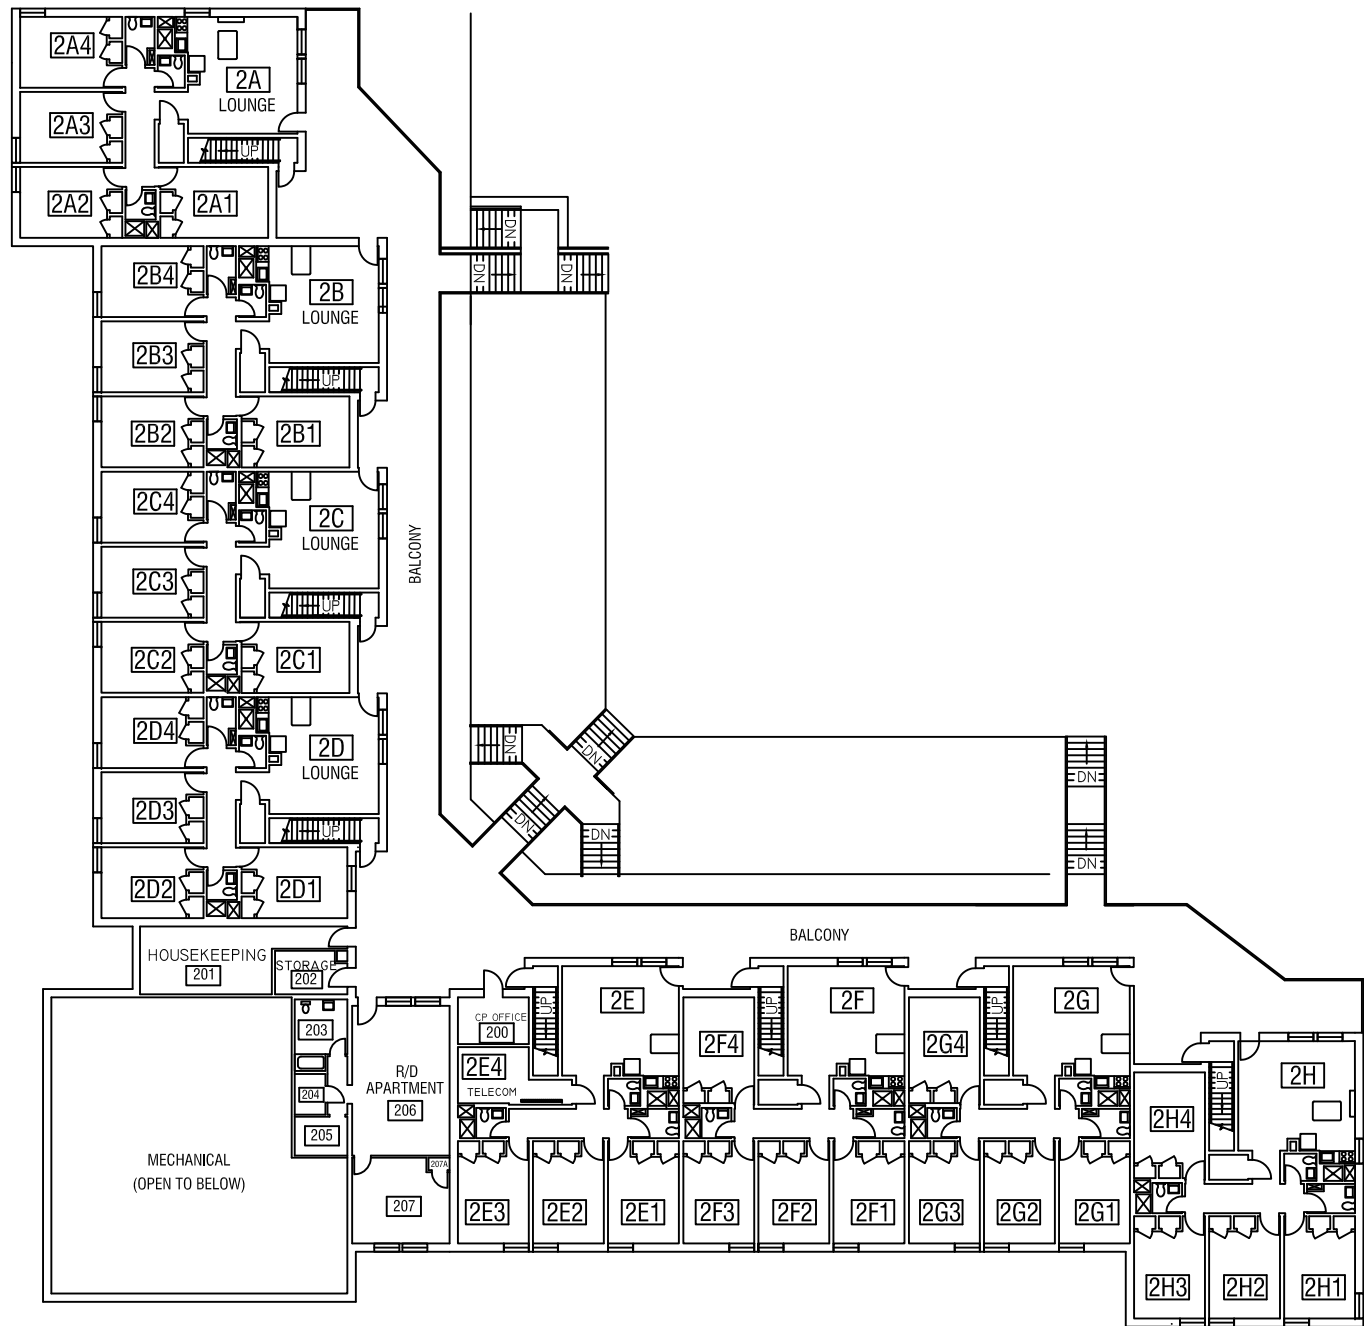


DWG. NO.:	REVISION DATE:
A-2	08-22-2018
BLDG. CODE:	SCALE:
CP	NTS
	DESIGN BY:
	PLA
	CHECKED BY:
	JCD

**RECORD FLOOR PLAN
CHESAPEAKE HALL BUILDING**

SECOND FLOOR PLAN

SALISBURY UNIVERSITY
 FACILITIES PLANNING & CAPITAL PROJECTS
 ARCHITECTURAL AND ENGINEERING SERVICES
 1101 CAMDEN AVENUE
 SALISBURY, MARYLAND 21801
 410 - 543 - 6215

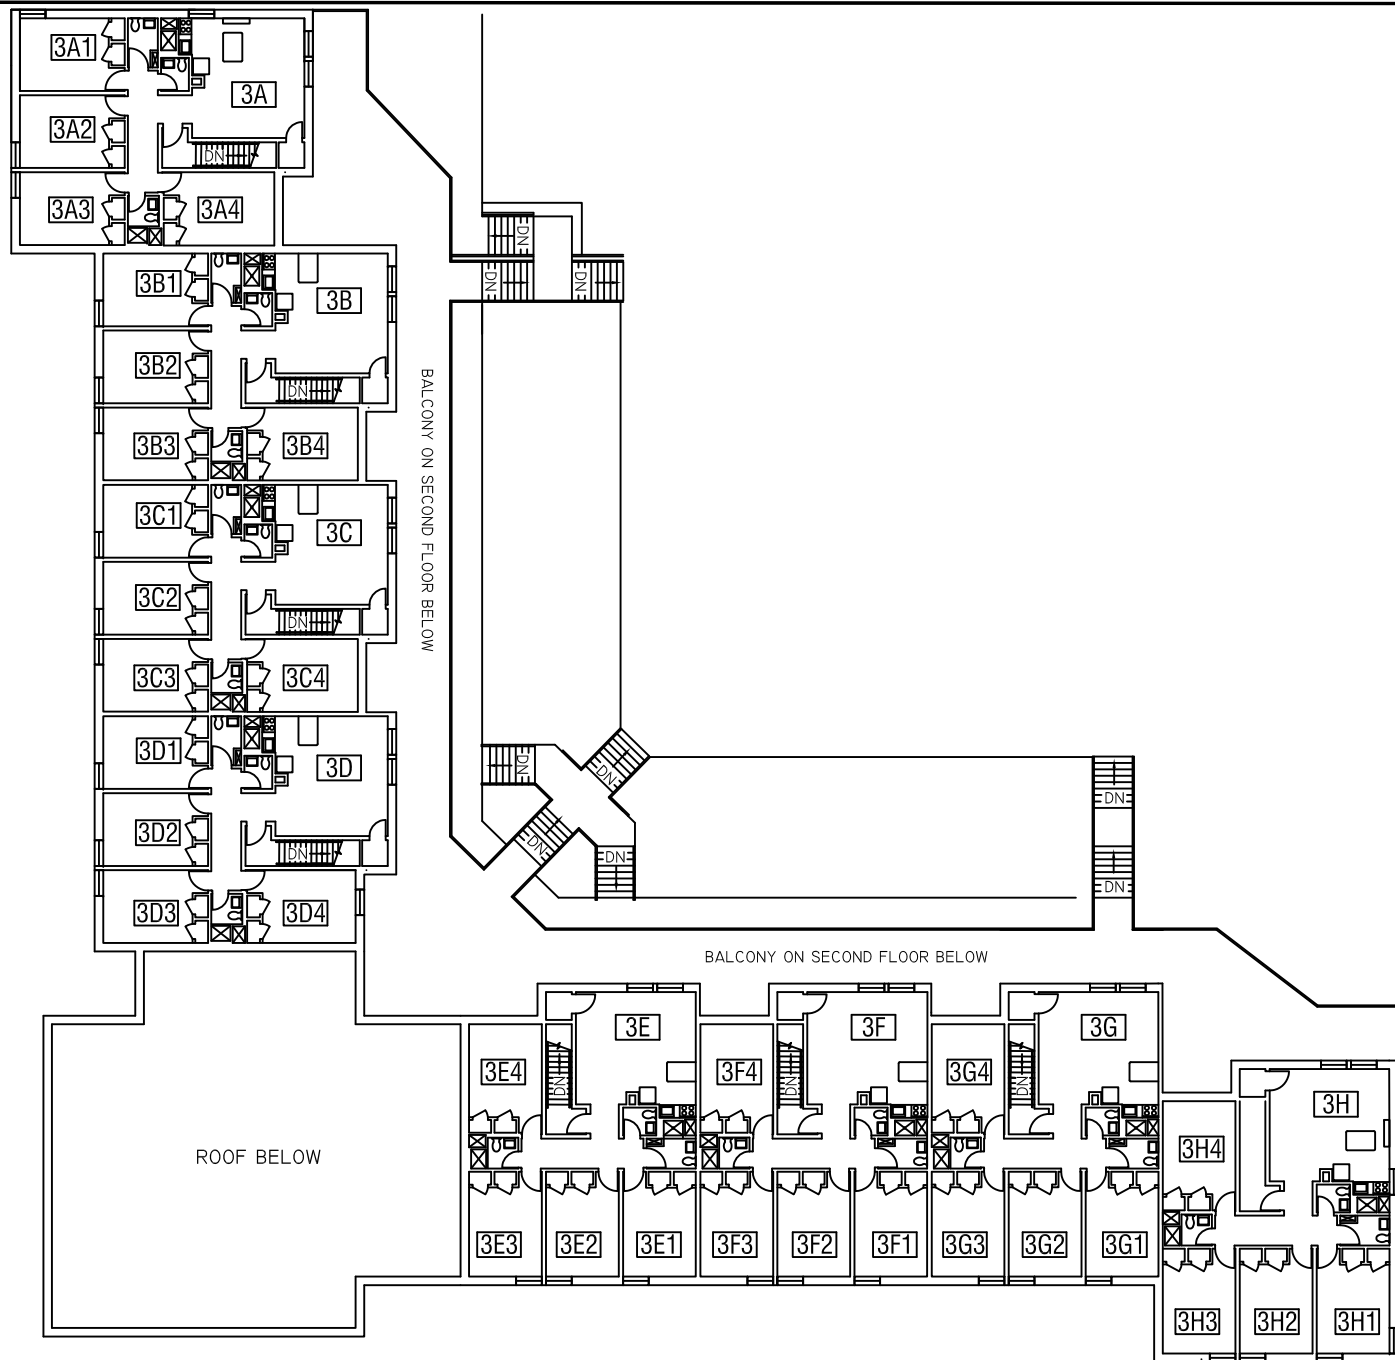

DWG. NO.:	REVISION DATE:
A-3	08-22-2018
BLDG. CODE:	SCALE:
CP	NTS
	DESIGN BY:
	PLA
	CHECKED BY:
	JCD

RECORD FLOOR PLAN
CHESAPEAKE HALL BUILDING

THIRD FLOOR PLAN

SALISBURY UNIVERSITY
 FACILITIES PLANNING & CAPITAL PROJECTS
 ARCHITECTURAL AND ENGINEERING SERVICES
 1101 CAMDEN AVENUE
 SALISBURY, MARYLAND 21801
 410 - 543 - 6215