


- Water Bottle Refill Station
- Standard Water Fountain

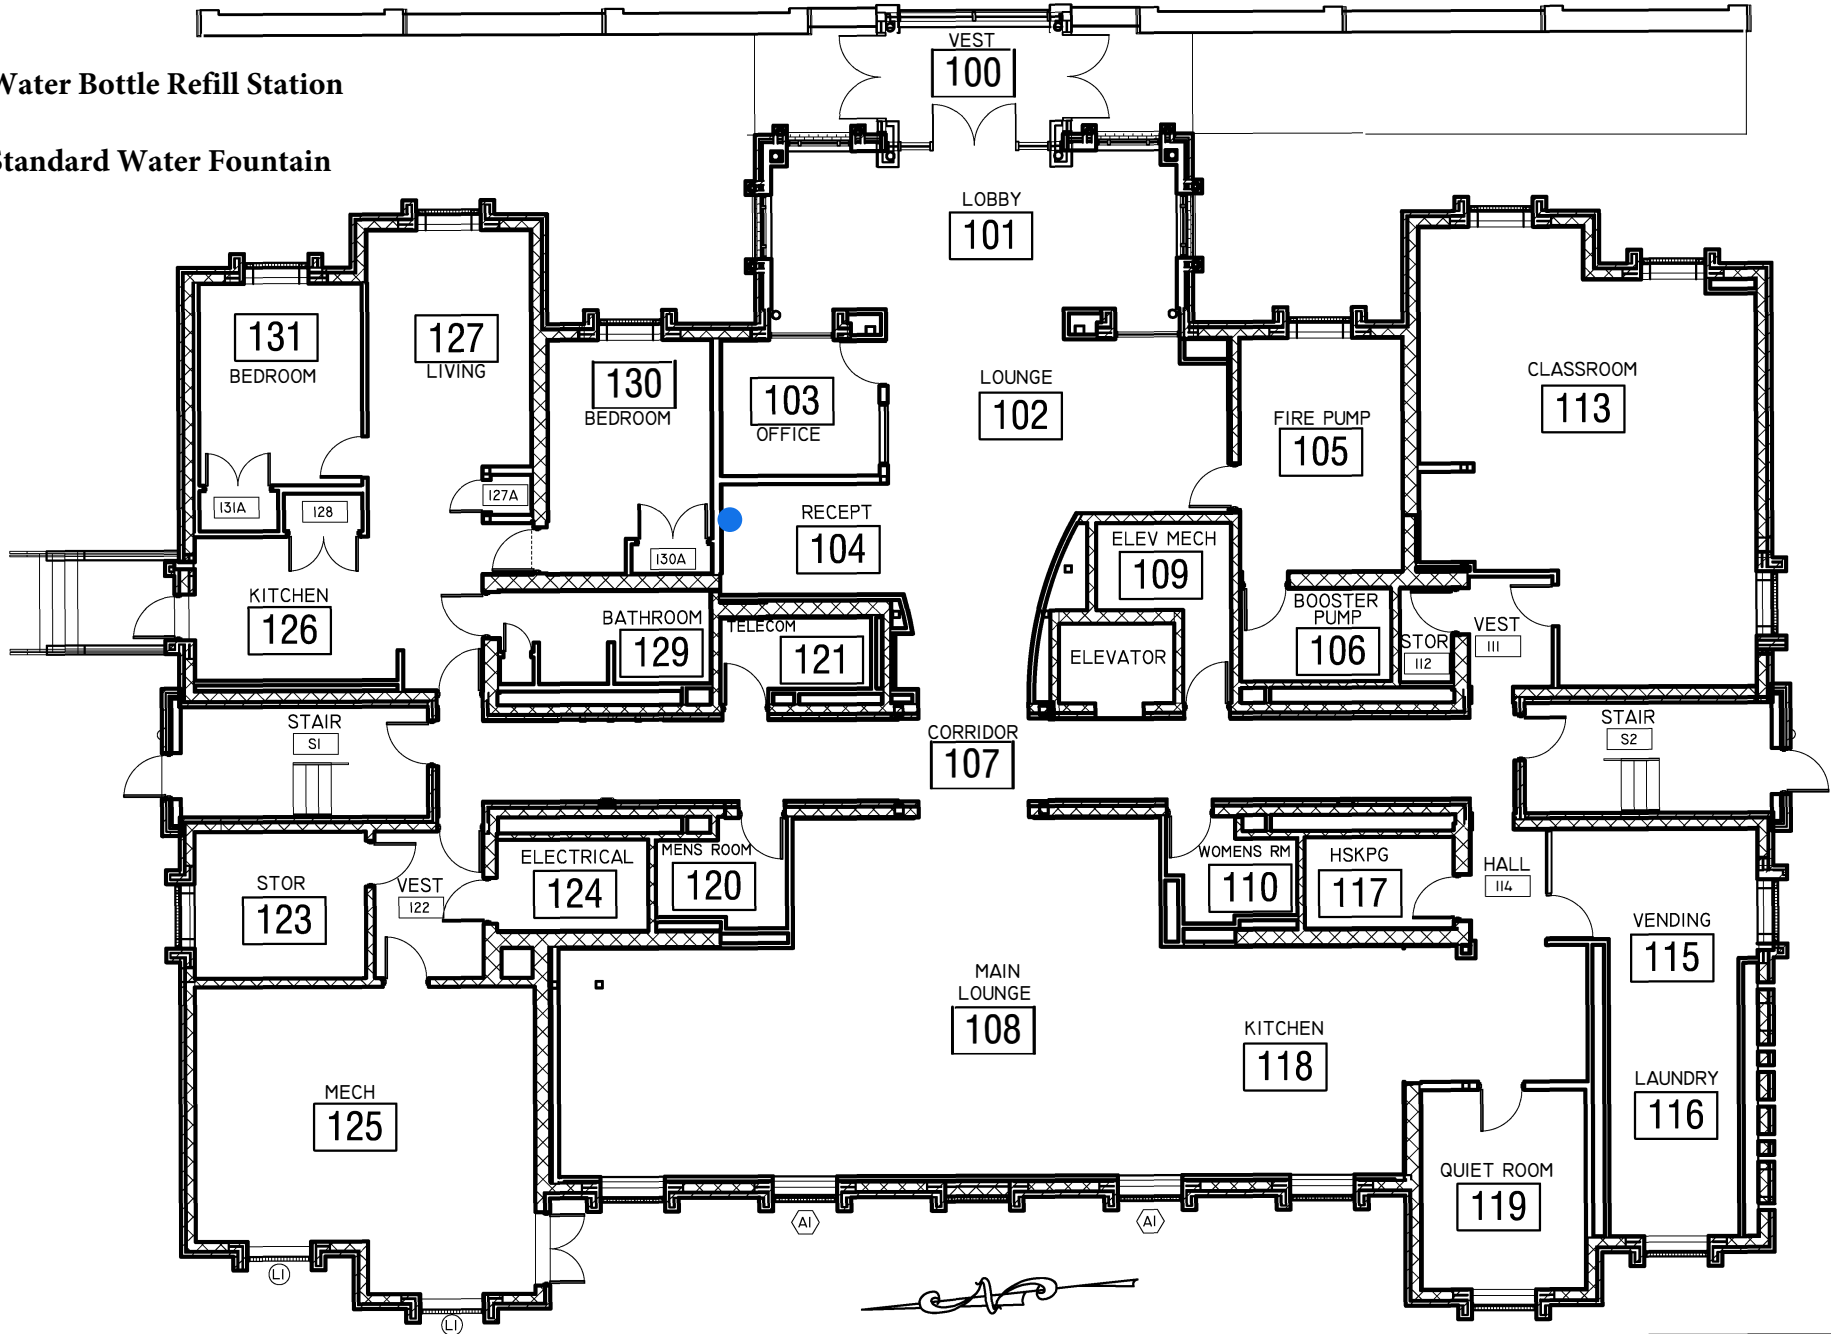


DWG. NO.:	REVISION DATE:
A-1	02-25-18
SCALE:	NTS
DESIGN BY:	
BLDG. CODE:	PLA
CHECKED BY:	JCD
CK	

**RECORD FLOOR PLAN
CHOPTANK HALL BUILDING**

FIRST FLOOR PLAN

SALISBURY UNIVERSITY
 FACILITIES PLANNING & CAPITAL PROJECTS
 ARCHITECTURAL AND ENGINEERING SERVICES
 1101 CAMDEN AVENUE
 SALISBURY, MARYLAND 21801
 410 - 543 - 6215

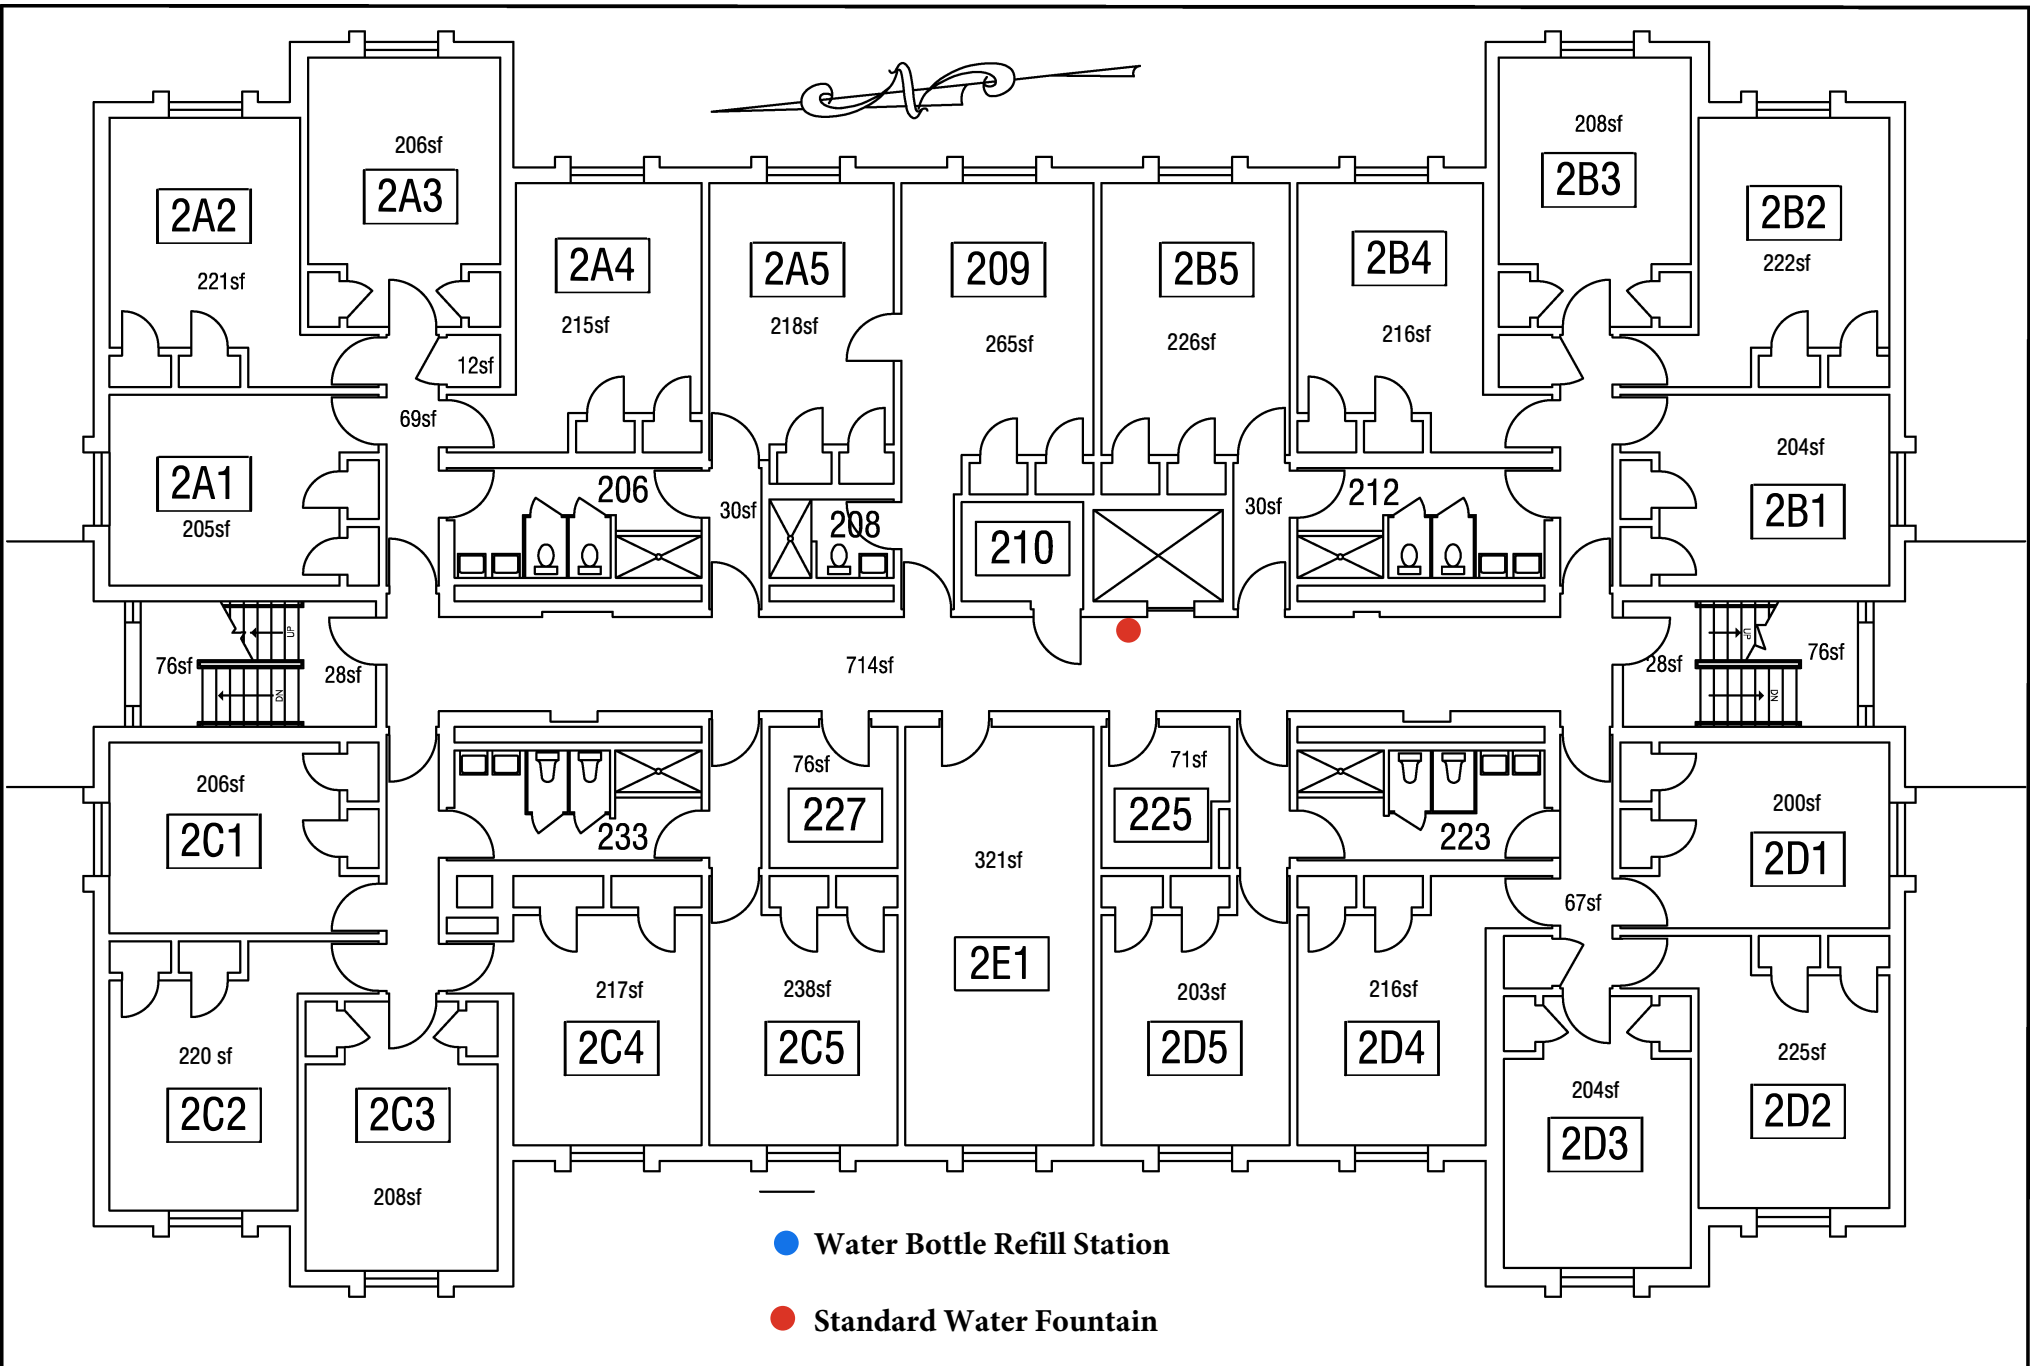


- Water Bottle Refill Station
- Standard Water Fountain

DWG. NO.:	REVISION DATE:
A-2	08-22-2018
BLDG. CODE:	SCALE:
CK	$\frac{1}{8}'' = 1'$
	DESIGN BY:
	PLA
	CHECKED BY:
	JCD


RECORD FLOOR PLAN
CHOPTANK HALL BUILDING

EXISTING
SECOND FLOOR PLAN
(TYPICAL OF FLOORS 2-6)

SALISBURY UNIVERSITY
 FACILITIES PLANNING & CAPITAL PROJECTS
 ARCHITECTURAL AND ENGINEERING SERVICES
 1101 CAMDEN AVENUE
 SALISBURY, MARYLAND 21801
 410 - 543 - 6215

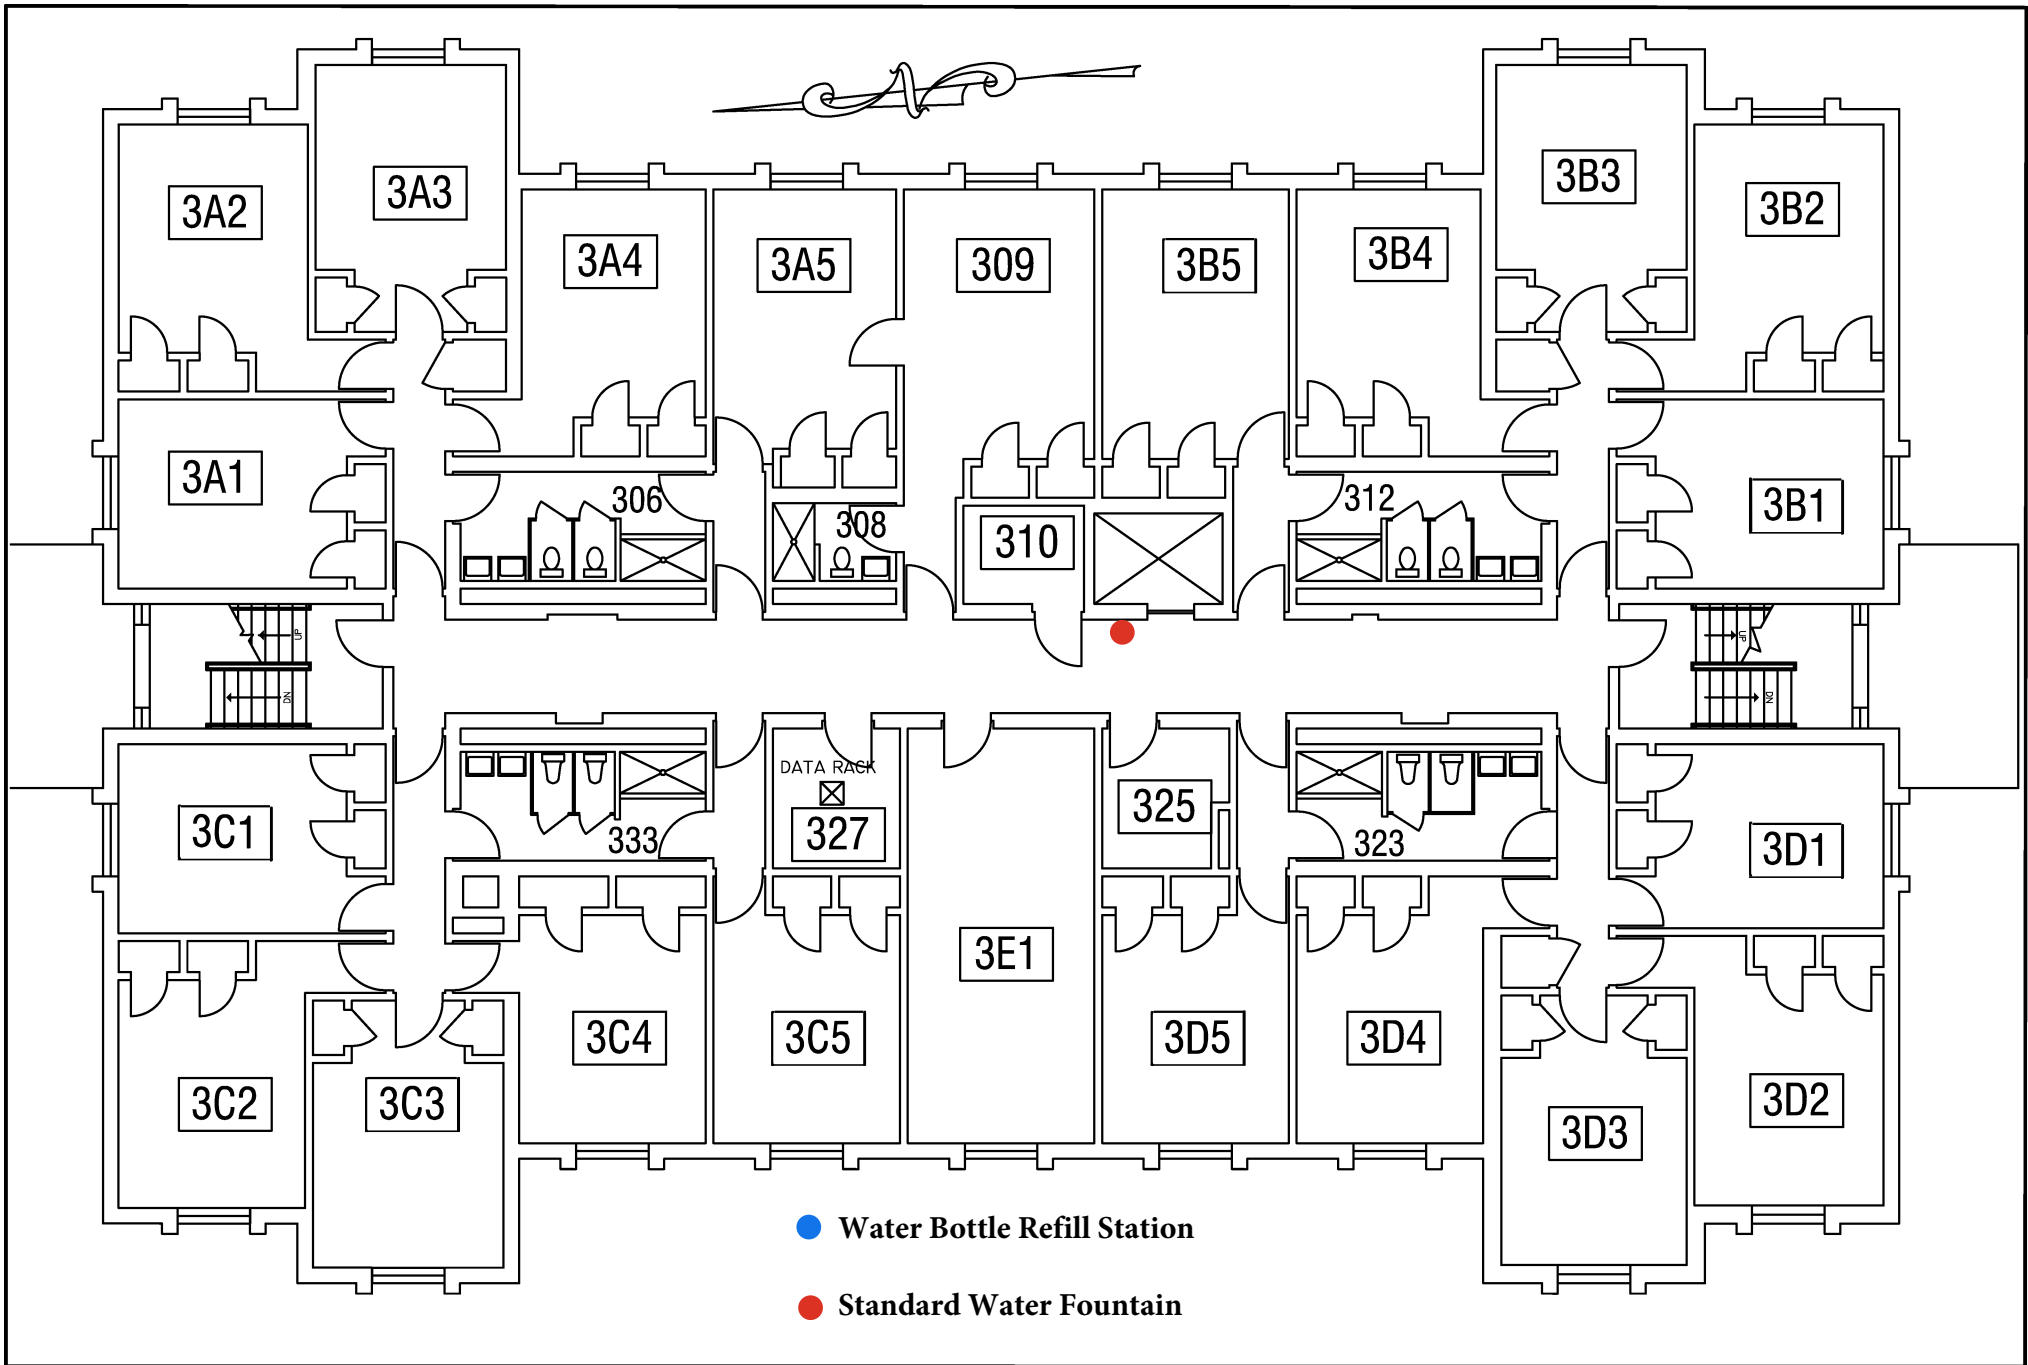

DWG. NO.: A-3	REVISION DATE: 08-22-2018 SCALE: $\frac{1}{8}" = 1'$ DESIGN BY: PLA CHECKED BY: JCD	RECORD FLOOR PLAN CHOPTANK HALL BUILDING	THIRD FLOOR PLAN	SALISBURY UNIVERSITY FACILITIES PLANNING & CAPITAL PROJECTS ARCHITECTURAL AND ENGINEERING SERVICES 1101 CAMDEN AVENUE SALISBURY, MARYLAND 21801 410 - 543 - 6215
-------------------------	----------------------------------------------------------------------------------------------------------------------	-----------------------------------------------------------	-------------------------	----------------------------------------------------------------------------------------------------------------------------------------------------------------------------------------

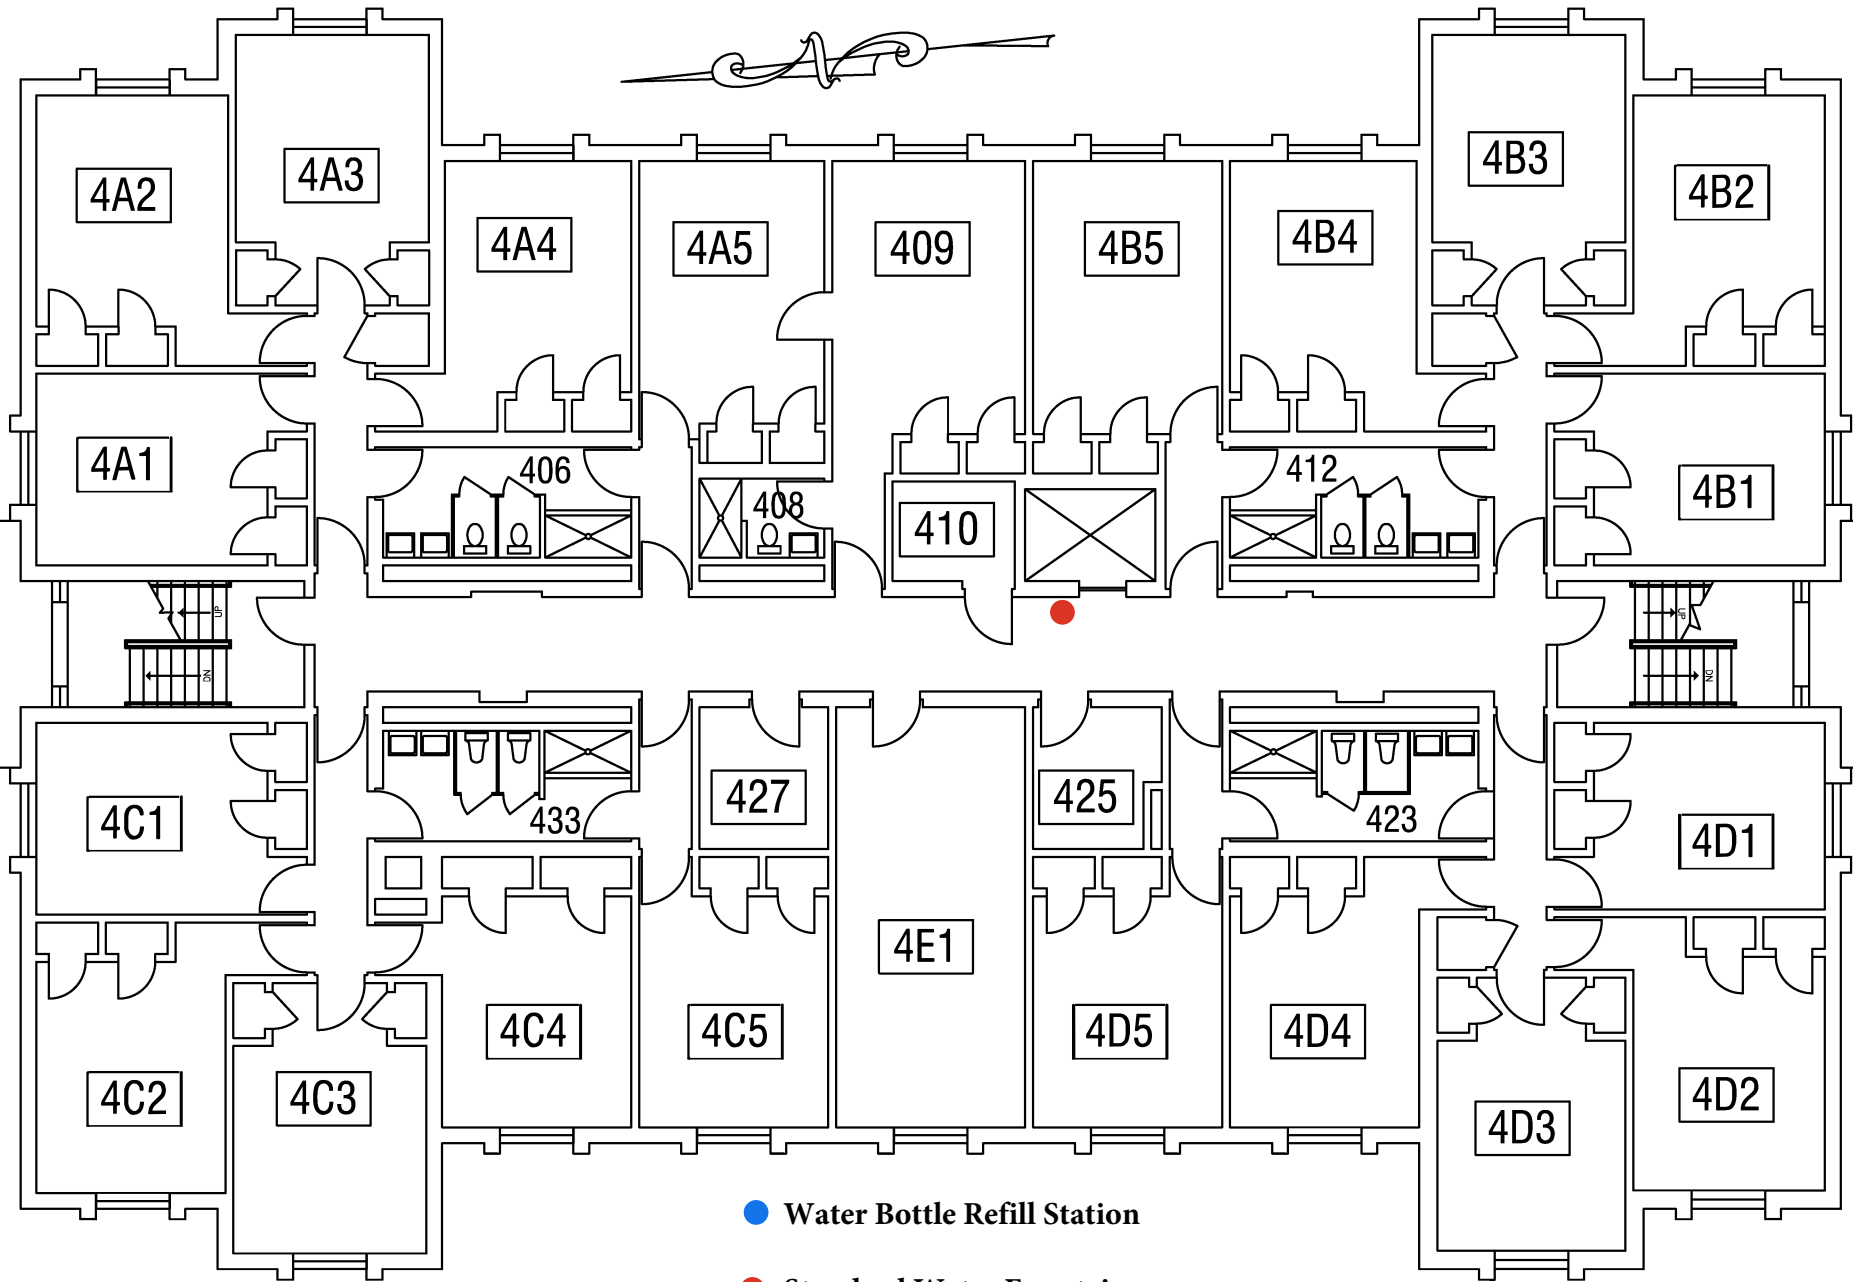


- Water Bottle Refill Station
- Standard Water Fountain

DWG. NO.:	REVISION DATE:
A-4	08-22-2018
BLDG. CODE:	SCALE:
CK	$\frac{1}{8}'' = 1'$
	DESIGN BY:
	PLA
	CHECKED BY:
	JCD

**RECORD FLOOR PLAN
CHOPTANK HALL BUILDING**

FOURTH FLOOR PLAN

SALISBURY UNIVERSITY
 FACILITIES PLANNING & CAPITAL PROJECTS
 ARCHITECTURAL AND ENGINEERING SERVICES
 1101 CAMDEN AVENUE
 SALISBURY, MARYLAND 21801
 410 - 543 - 6215

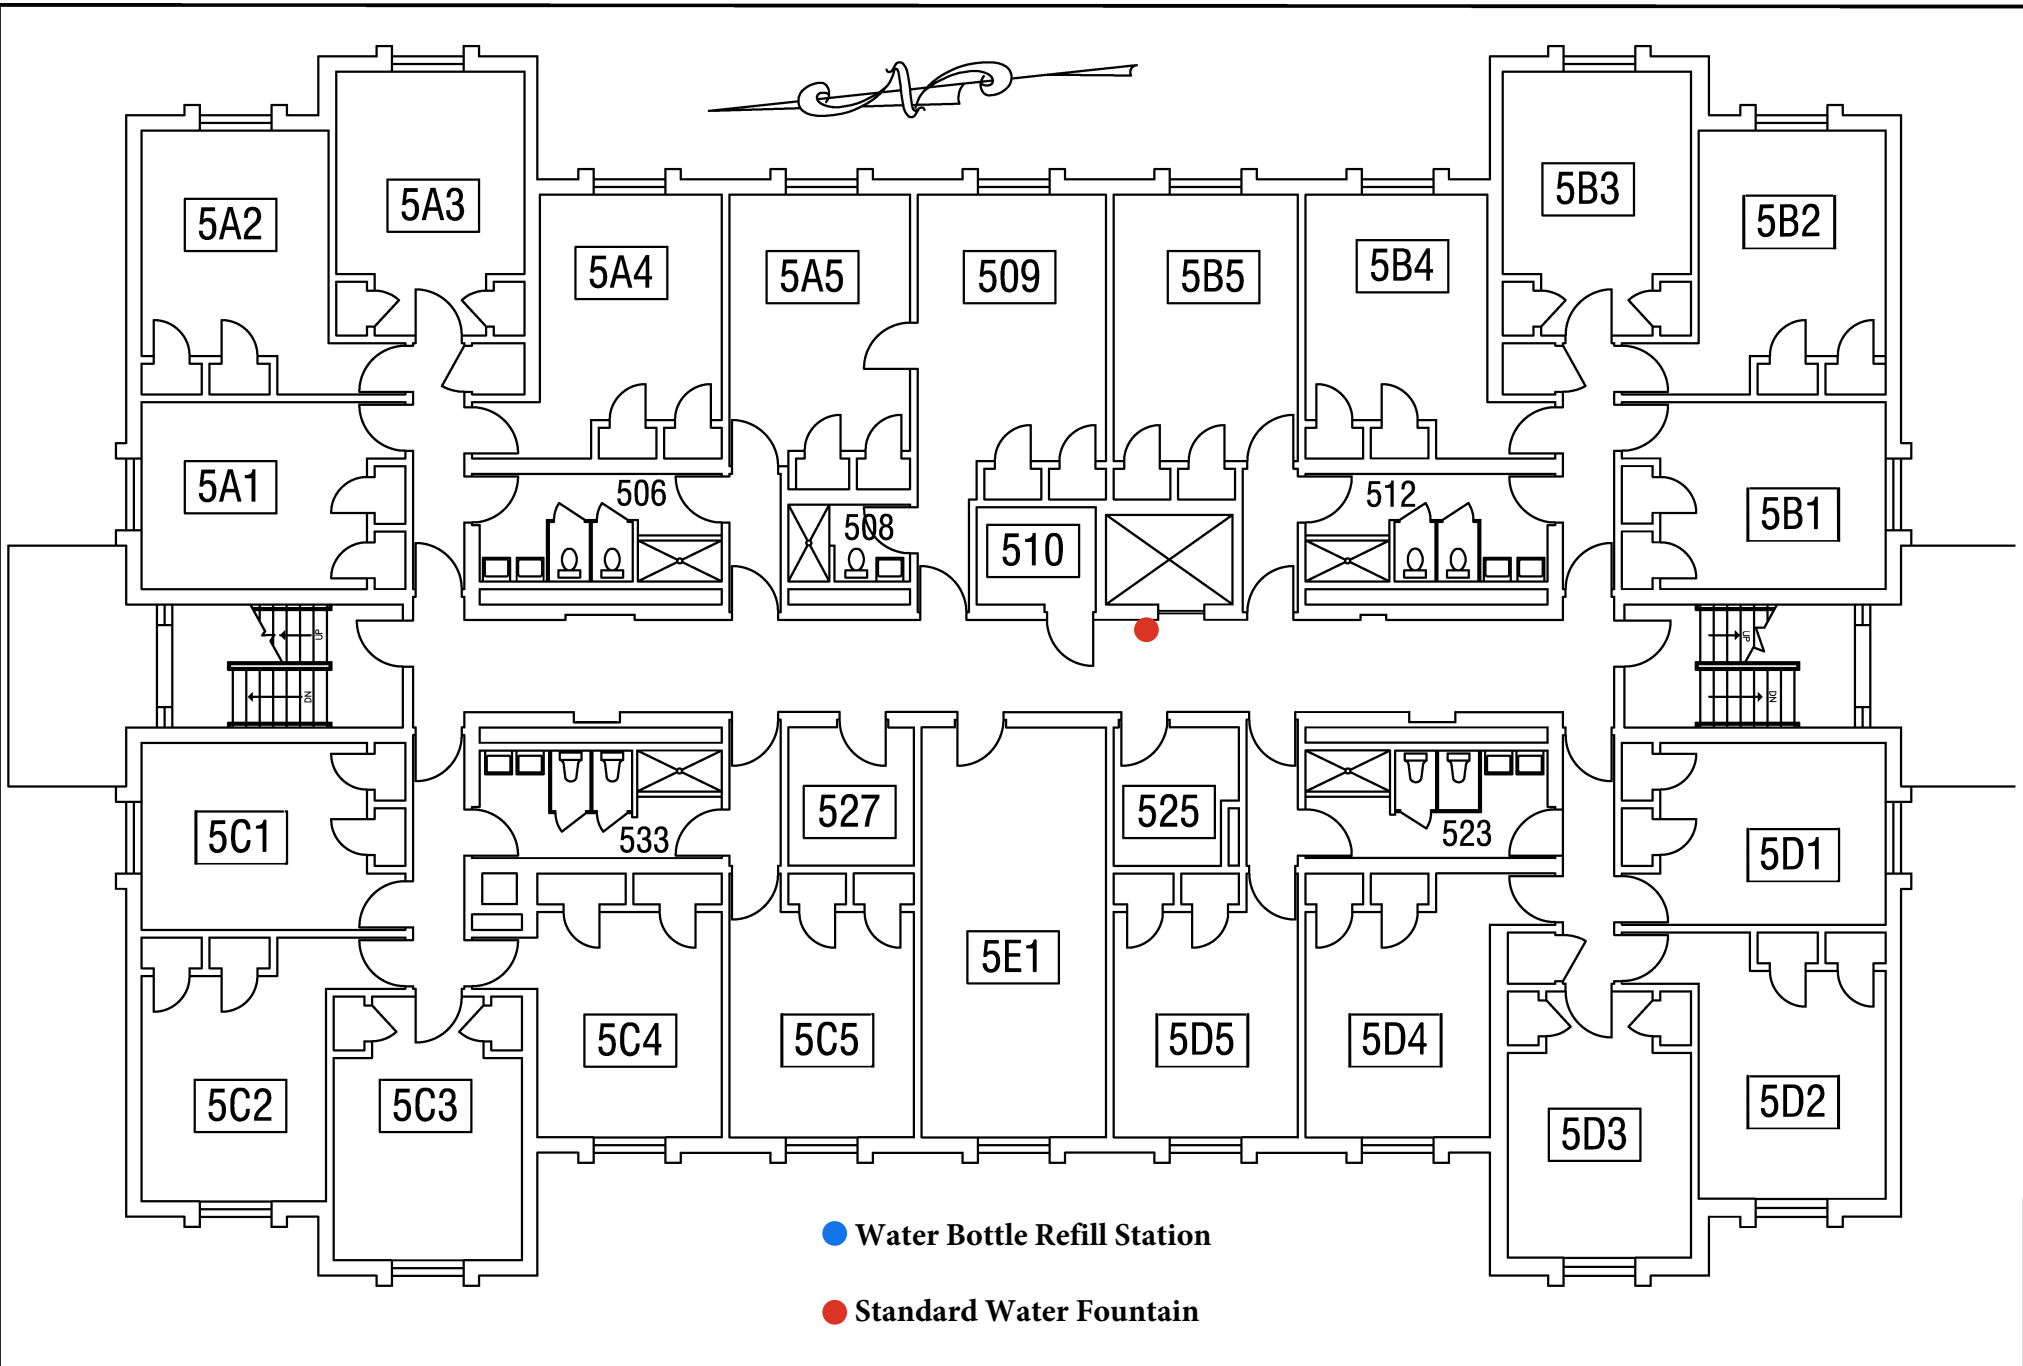


DWG. NO.:	REVISION DATE:
A-5	08-22-2018
	SCALE: $\frac{1}{8}'' = 1'$
	DESIGN BY: PLA
BLDG. CODE:	CHECKED BY: JCD
CK	

RECORD FLOOR PLAN
CHOPTANK HALL BUILDING

FIFTH FLOOR PLAN

SALISBURY UNIVERSITY
 FACILITIES PLANNING & CAPITAL PROJECTS
 ARCHITECTURAL AND ENGINEERING SERVICES
 1101 CAMDEN AVENUE
 SALISBURY, MARYLAND 21801
 410 - 543 - 6215

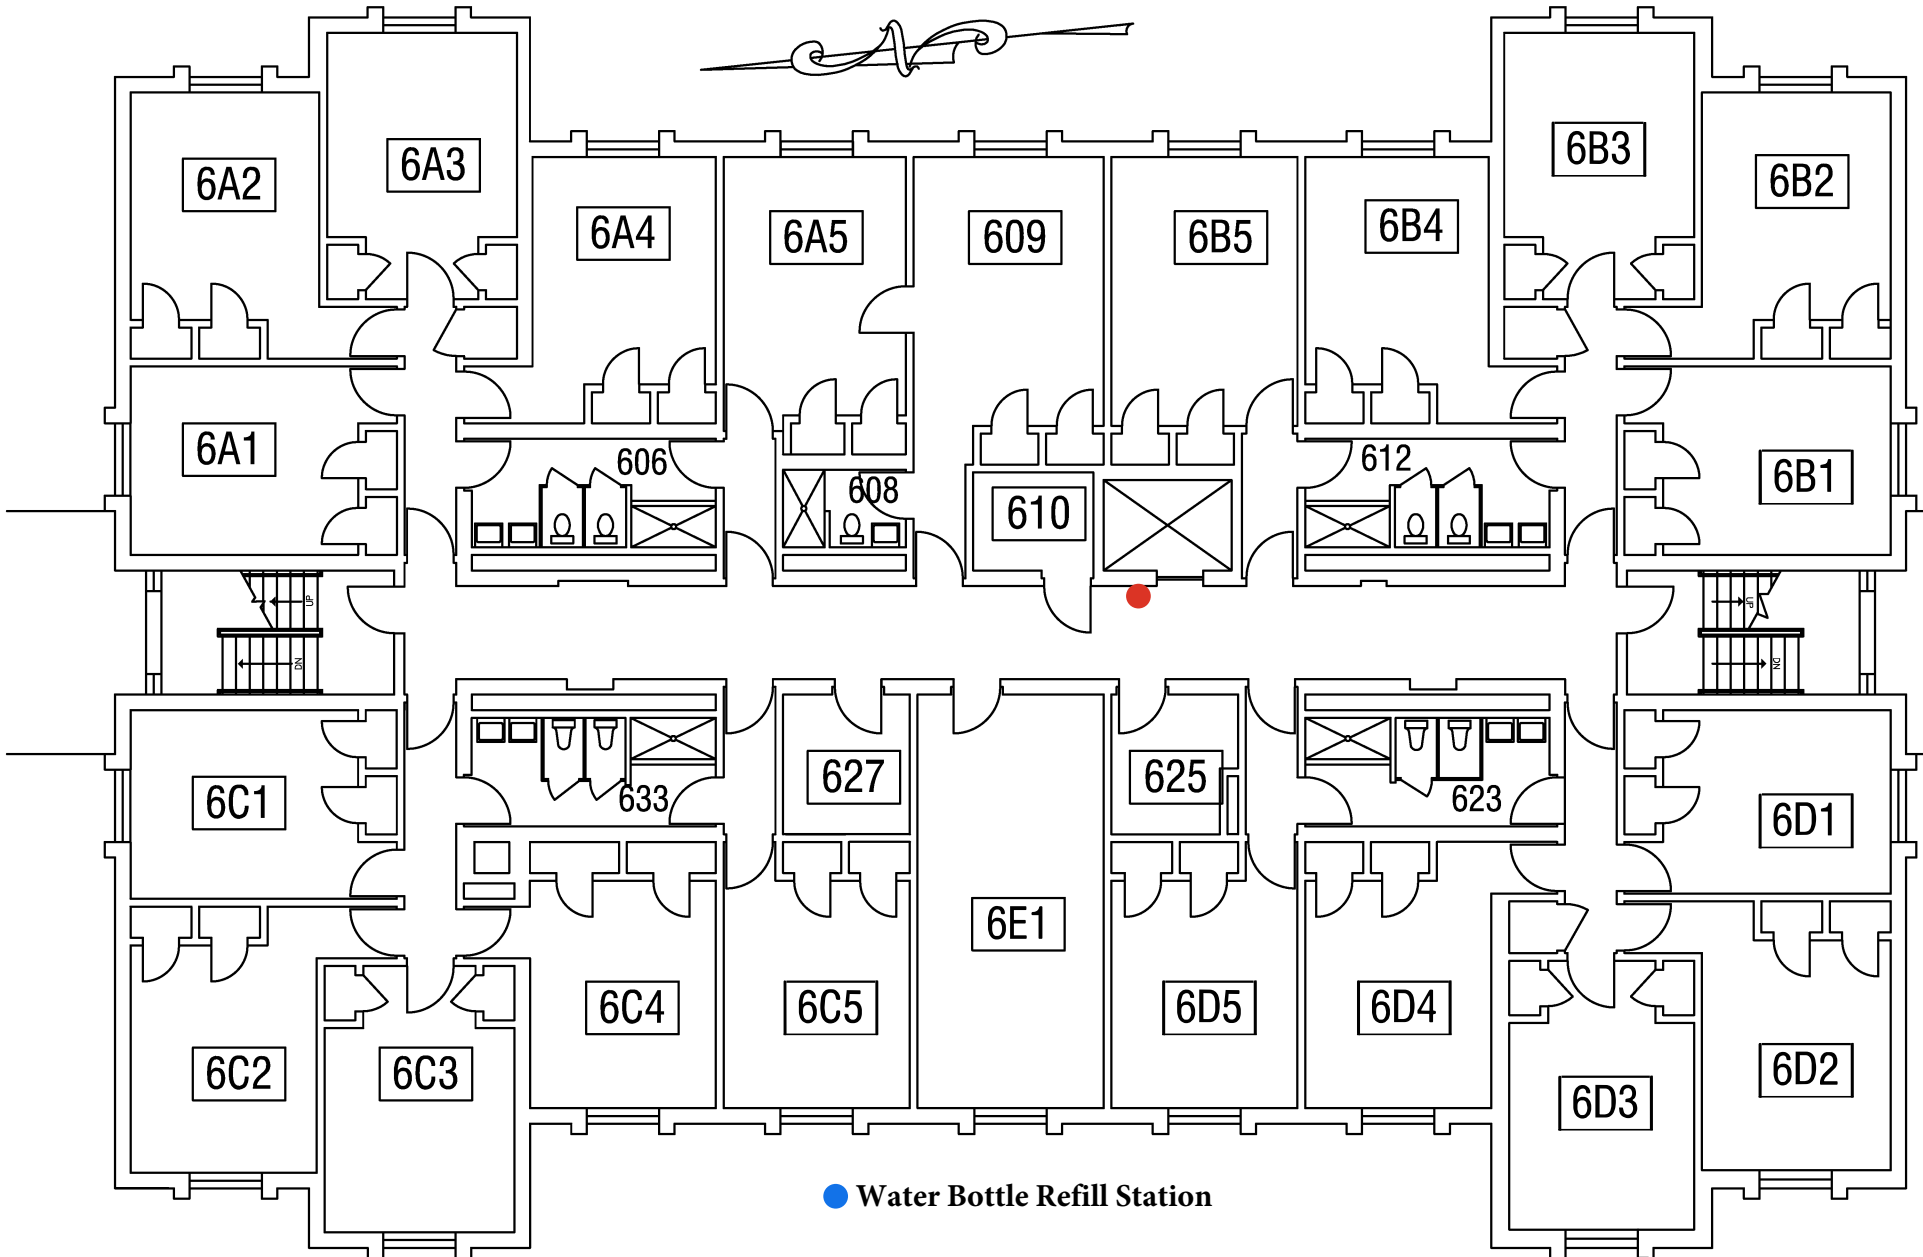

- Water Bottle Refill Station
- Standard Water Fountain

DWG. NO.:	REVISION DATE:
A-6	08-22-2018
BLDG. CODE:	SCALE:
CK	$\frac{1}{8}'' = 1'$
	DESIGN BY:
	PLA
	CHECKED BY:
	JCD

RECORD FLOOR PLAN
CHOPTANK HALL BUILDING

SIXTH FLOOR PLAN

SALISBURY UNIVERSITY
 FACILITIES PLANNING & CAPITAL PROJECTS
 ARCHITECTURAL AND ENGINEERING SERVICES
 1101 CAMDEN AVENUE
 SALISBURY, MARYLAND 21801
 410 - 543 - 6215