


● Water Bottle Refill Station

● Standard Water Fountain

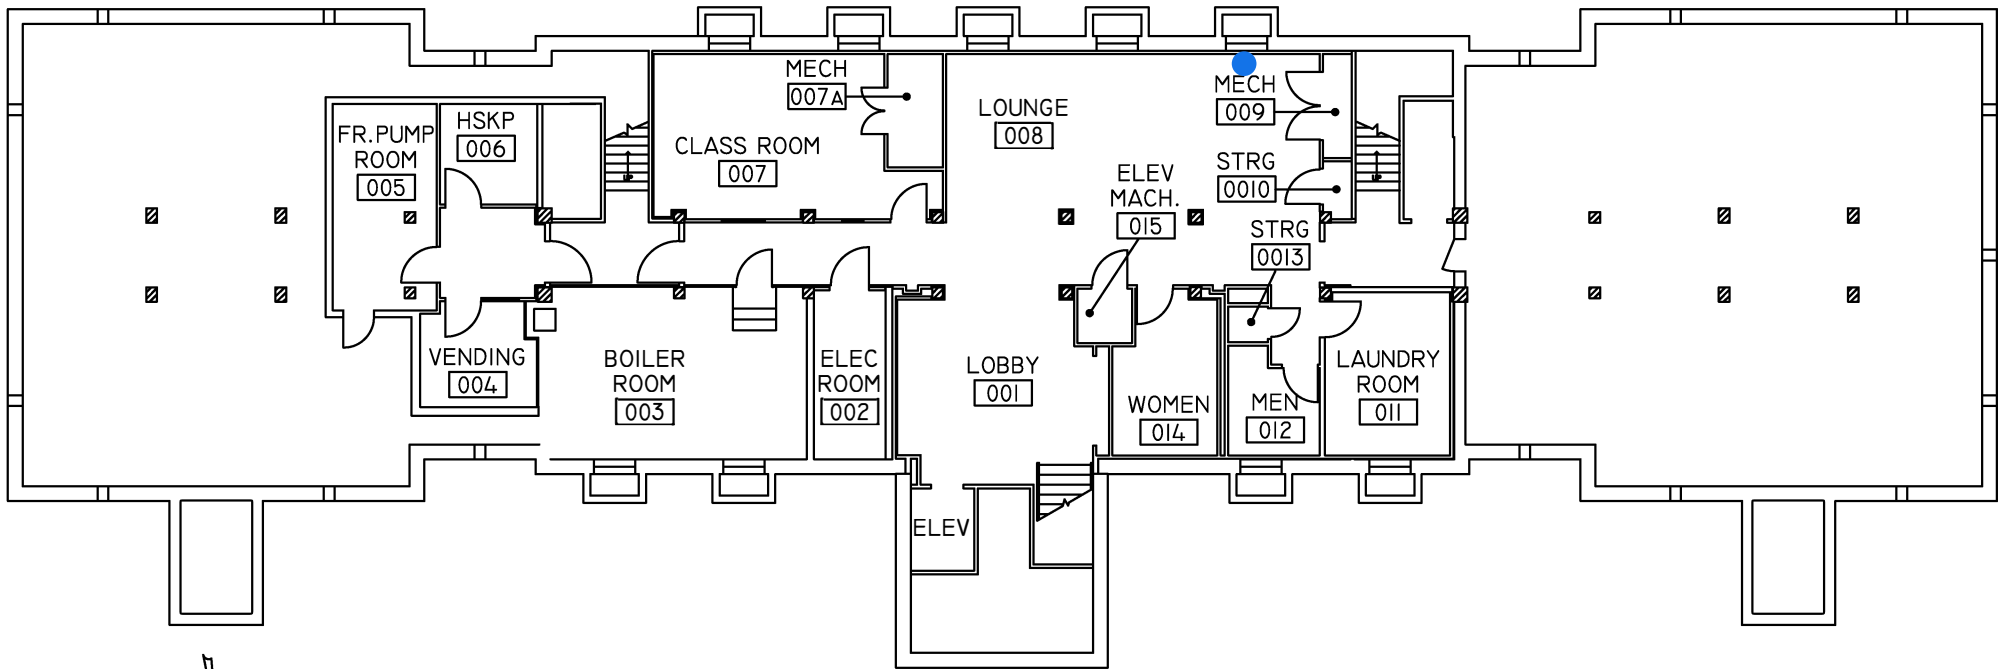

DWG. NO.:

A-0

BLDG. CODE:

PO

REVISION DATE:
08-22-2018

SCALE: **NTS**

DESIGN BY: **PLA**

CHECKED BY:
JA

**RECORD FLOOR PLAN
POCOMOKE HALL**


BASEMENT FLOOR PLAN

SALISBURY UNIVERSITY

FACILITIES PLANNING & CAPITAL PROJECTS
ARCHITECTURAL AND ENGINEERING SERVICES

1101 CAMDEN AVENUE
SALISBURY, MARYLAND 21801

410 - 543 - 6215

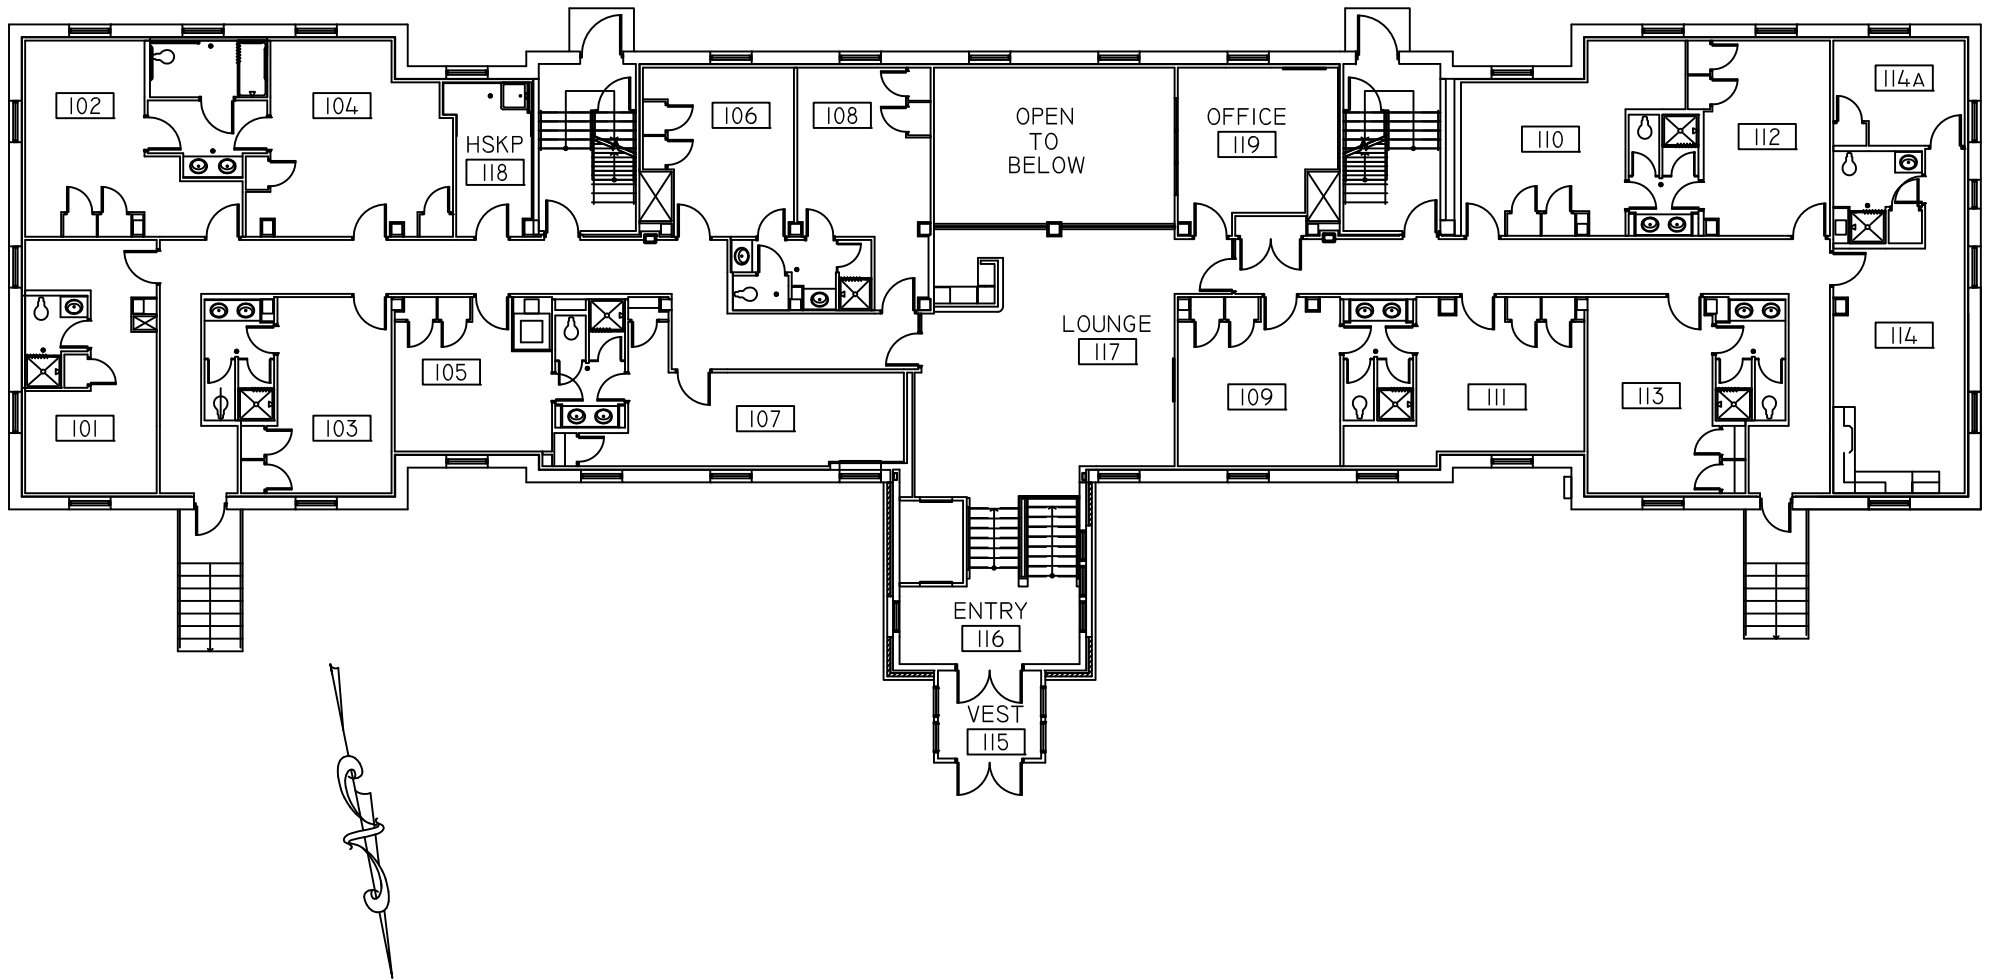

DWG. NO.:
A-1

BLDG. CODE:
PO

REVISION DATE:
08-22-2011

SCALE:
NTS


DESIGN BY:
PLA

CHECKED BY:
JA

**RECORD FLOOR PLAN
 POCOMOKE HALL**

FIRST FLOOR PLAN

SALISBURY UNIVERSITY
 FACILITIES PLANNING & CAPITAL PROJECTS
 ARCHITECTURAL AND ENGINEERING SERVICES
 1101 CAMDEN AVENUE
 SALISBURY, MARYLAND 21801
 410 - 543 - 6215

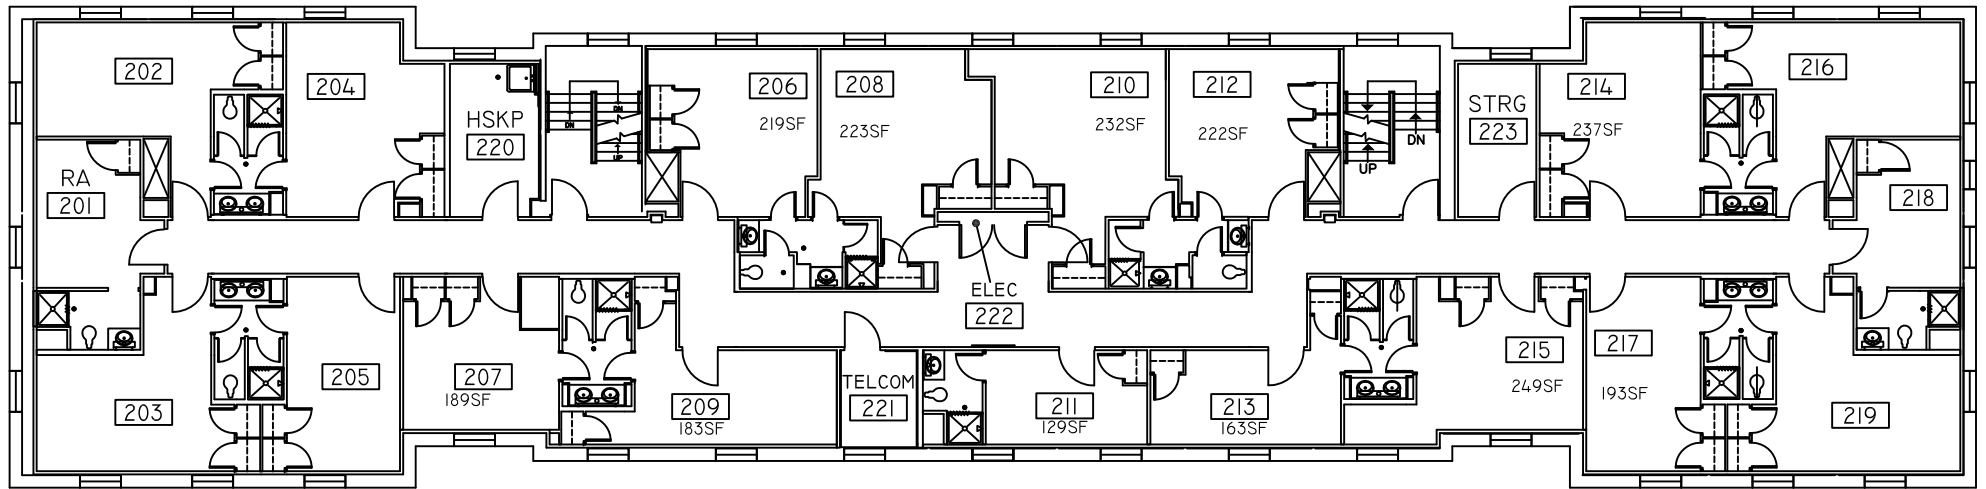


DWG. NO.:	REVISION DATE:
A-2	08-22-2018
	SCALE: NTS
	DESIGN BY: PLA
BLDG. CODE:	CHECKED BY: JA
PO	

**RECORD FLOOR PLAN
POCOMOKE HALL**

SECOND FLOOR PLAN

SALISBURY UNIVERSITY
 FACILITIES PLANNING & CAPITAL PROJECTS
 ARCHITECTURAL AND ENGINEERING SERVICES
 1101 CAMDEN AVENUE
 SALISBURY, MARYLAND 21801
 410 - 543 - 6215

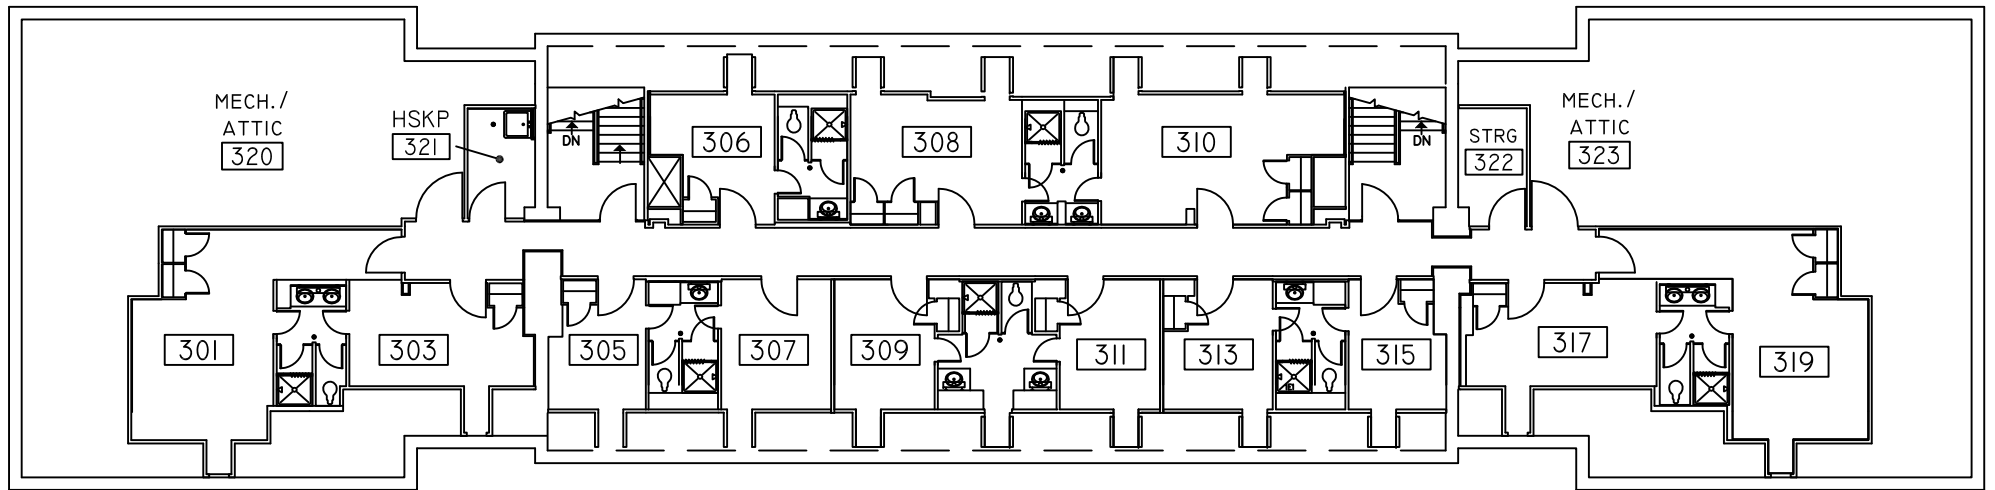

DWG. NO.:	REVISION DATE:
A-3	08-22-2018
BLDG. CODE:	SCALE:
PO	NTS
	DESIGN BY:
	PLA
	CHECKED BY:
	JA

RECORD FLOOR PLAN
POCOMOKE HALL

THIRD FLOOR PLAN

SALISBURY UNIVERSITY
 FACILITIES PLANNING & CAPITAL PROJECTS
 ARCHITECTURAL AND ENGINEERING SERVICES
 1101 CAMDEN AVENUE
 SALISBURY, MARYLAND 21801
 410 - 543 - 6215