


● Water Bottle Refill Station

● Standard Water Fountain

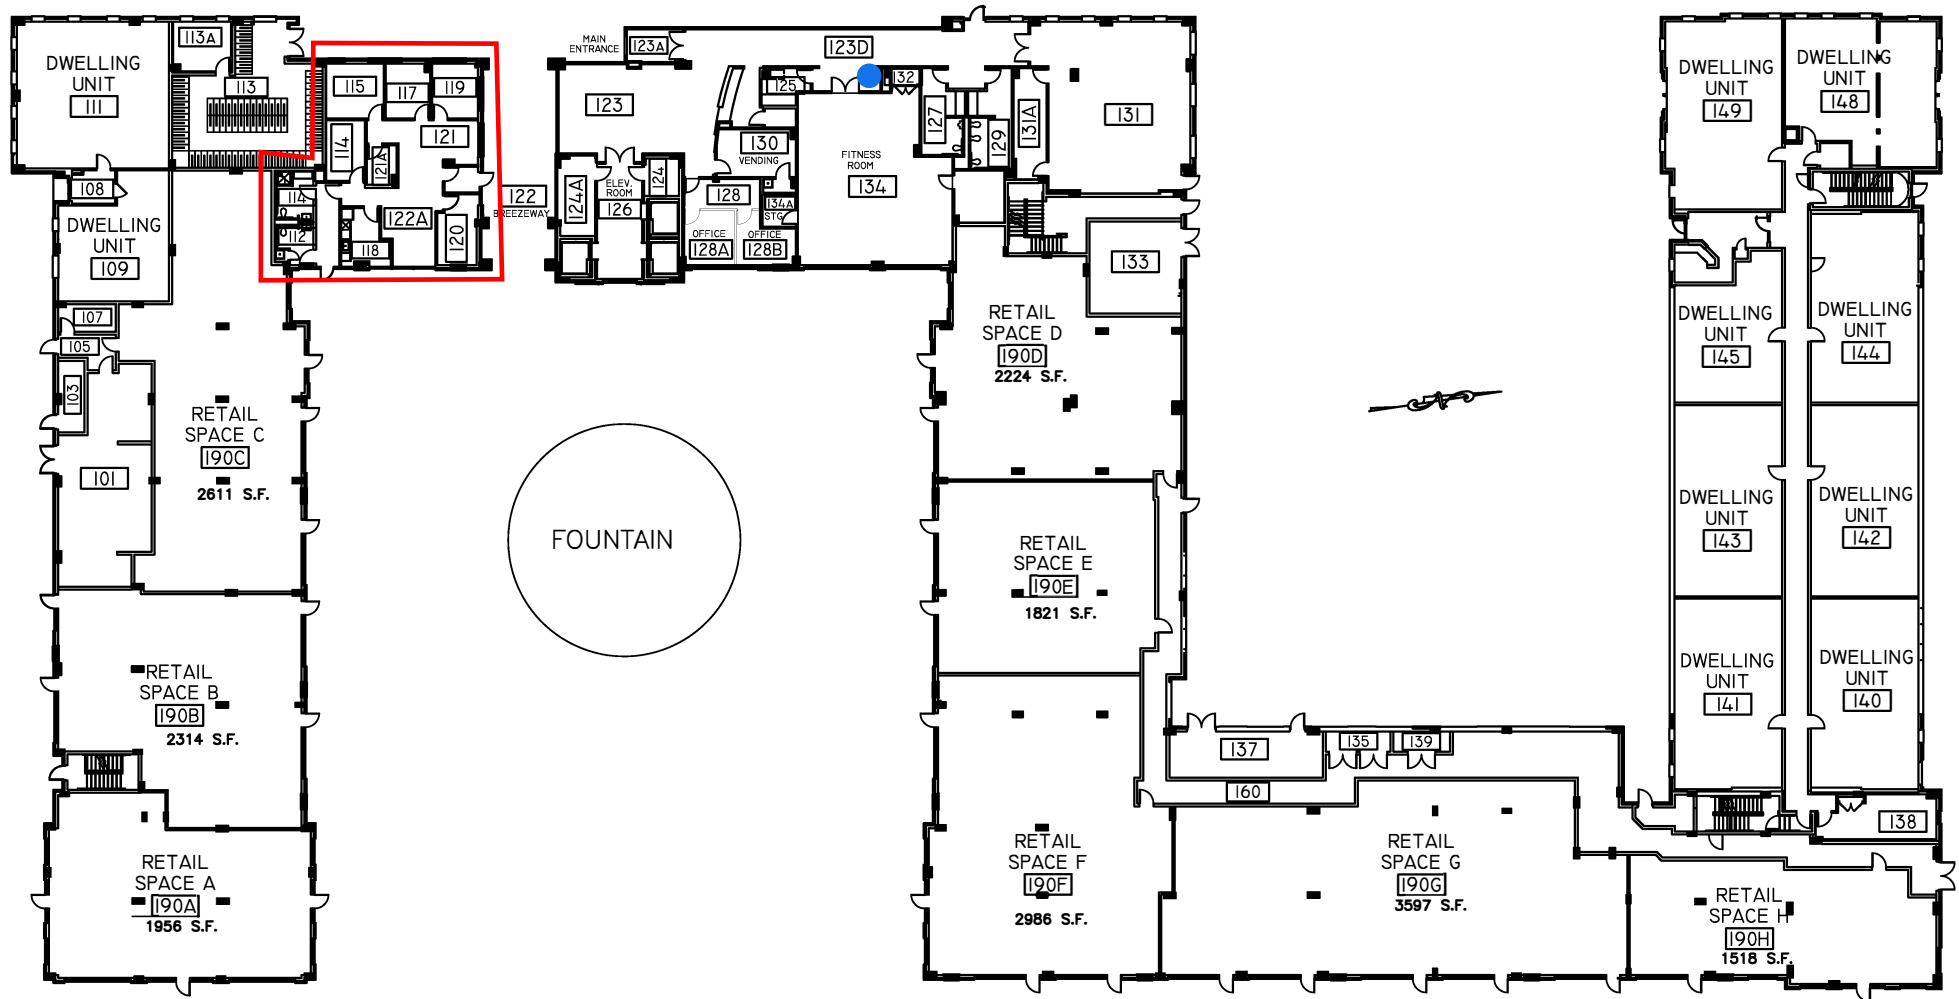


DWG. NO.:	REVISION DATE:
A-1	08-22-2018
	SCALE: N.T.S.
	DESIGN BY: PLA
BLDG. CODE:	CHECKED BY: JCD
SG	

**RECORD FLOOR PLAN
SEA GULL SQUARE**

FIRST FLOOR PLAN

SALISBURY UNIVERSITY
 FACILITIES PLANNING & CAPITAL PROJECTS
 ARCHITECTURAL AND ENGINEERING SERVICES
 1101 CAMDEN AVENUE
 SALISBURY, MARYLAND 21801
 410 - 543 - 6215

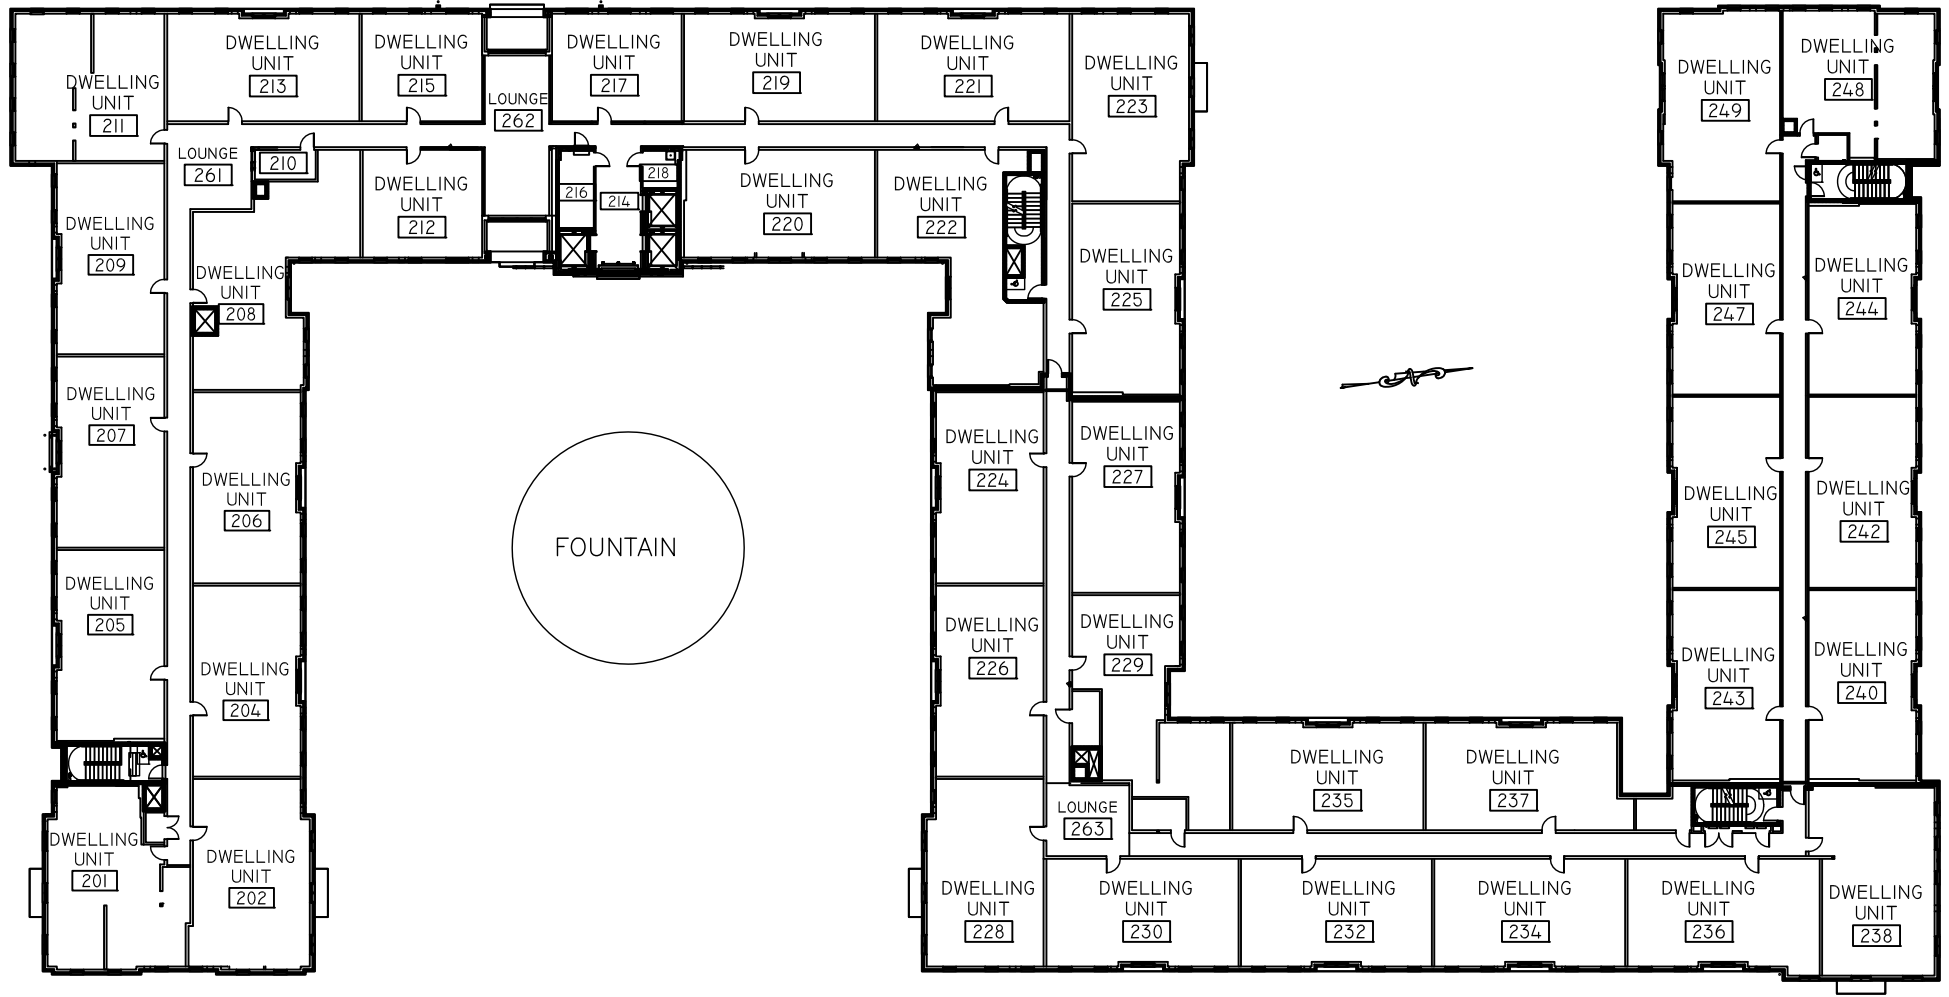


DWG. NO.:	REVISION DATE:
A-2	08-22-2011
BLDG. CODE:	SCALE:
SG	NTS
	DESIGN BY:
	PLA
	CHECKED BY:
	JCD

RECORD FLOOR PLAN
SEA GULL SQUARE

SECOND FLOOR PLAN

SALISBURY UNIVERSITY
 FACILITIES PLANNING & CAPITAL PROJECTS
 ARCHITECTURAL AND ENGINEERING SERVICES
 1101 CAMDEN AVENUE
 SALISBURY, MARYLAND 21801
 410 - 543 - 6215

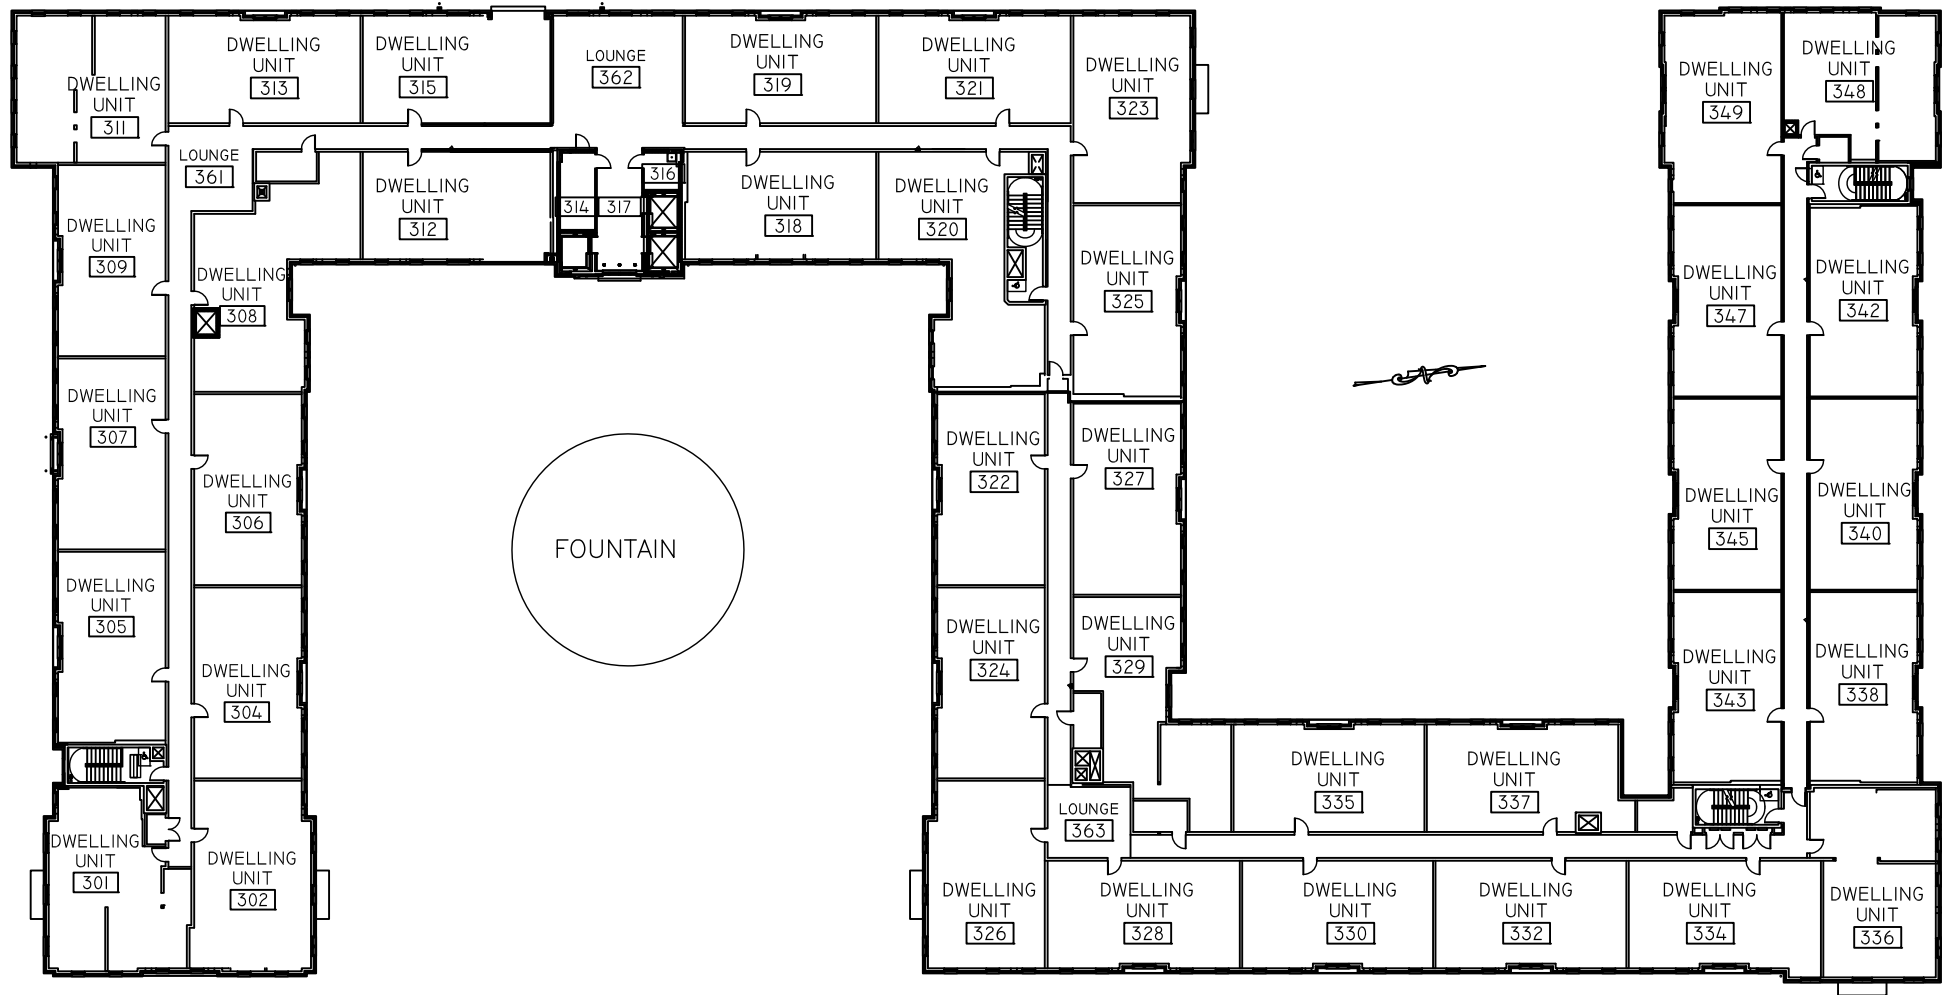


DWG. NO.:	REVISION DATE:
A-3	08-22-2018
	SCALE: NTS
BLDG. CODE:	DESIGN BY: PLA
SG	CHECKED BY: JCD

RECORD FLOOR PLAN
SEA GULL SQUARE

THIRD FLOOR PLAN

SALISBURY UNIVERSITY
 FACILITIES PLANNING & CAPITAL PROJECTS
 ARCHITECTURAL AND ENGINEERING SERVICES
 1101 CAMDEN AVENUE
 SALISBURY, MARYLAND 21801
 410 - 543 - 6215

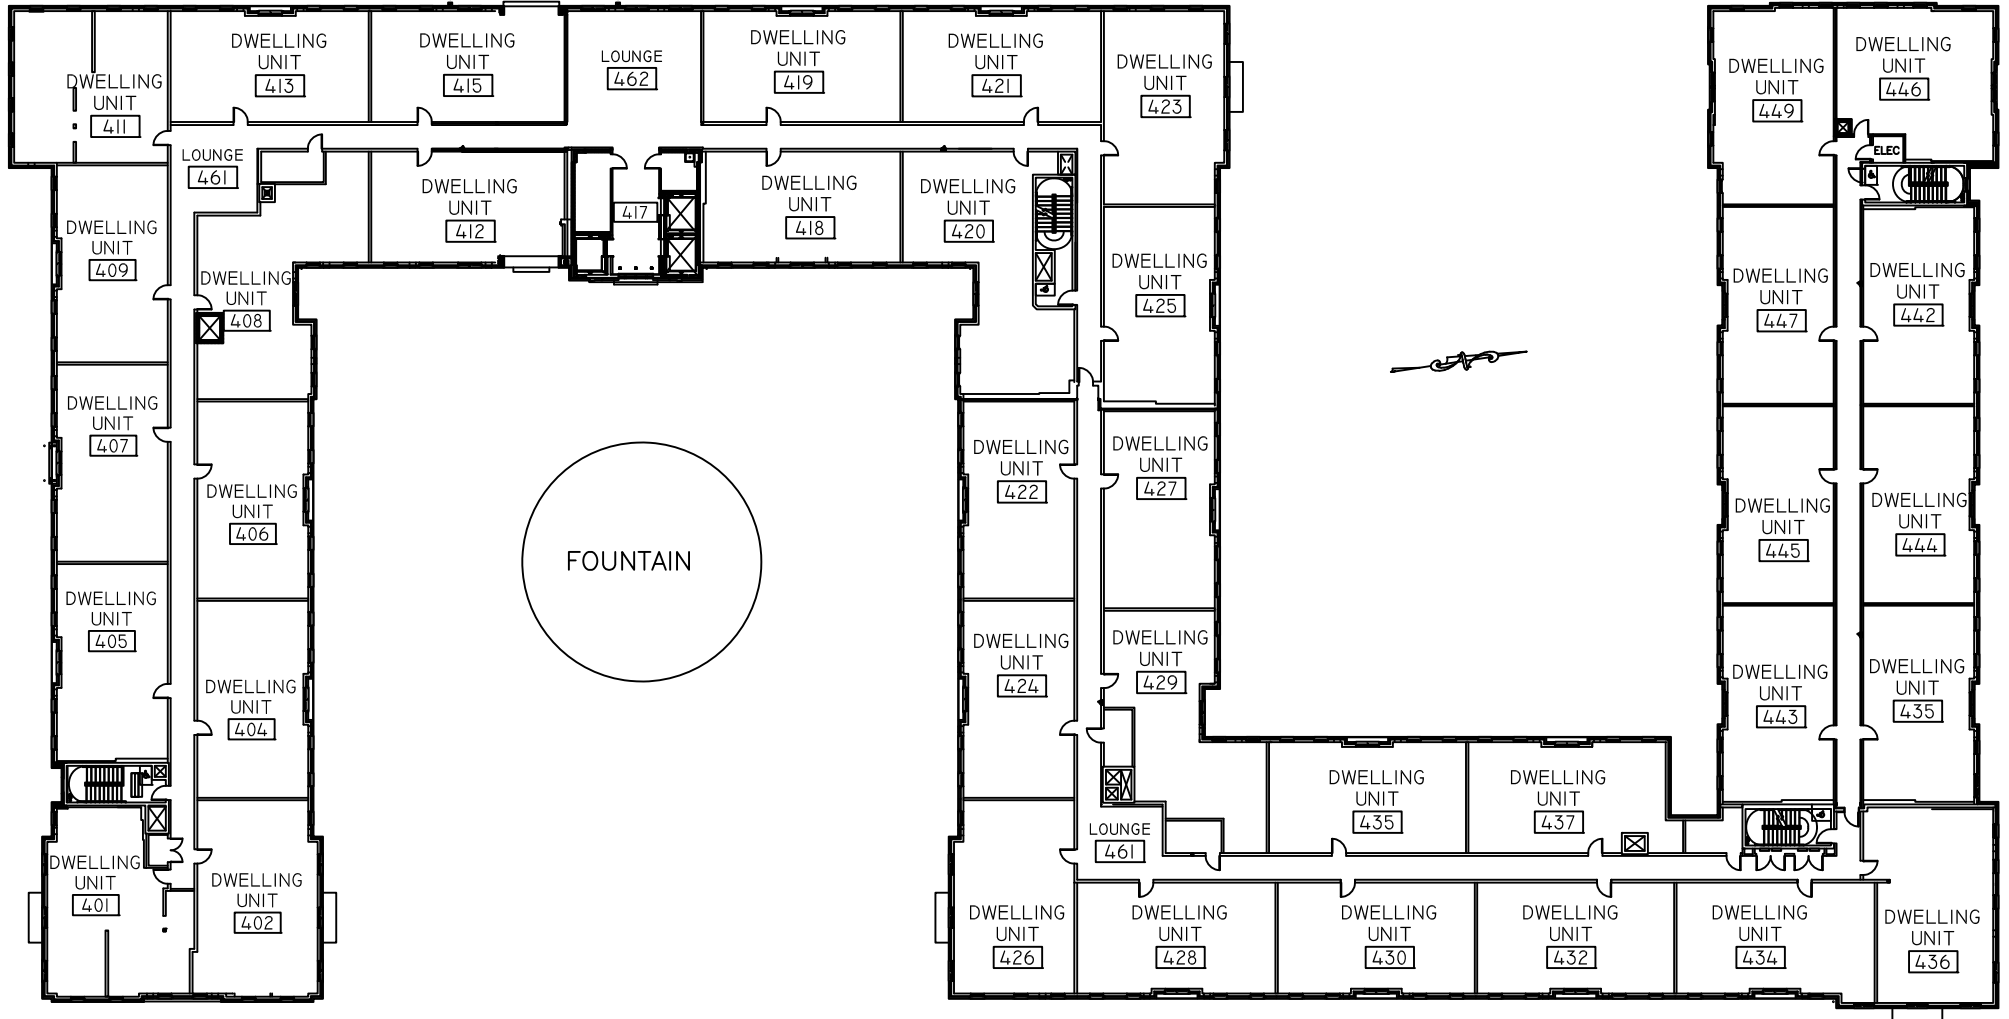

DWG. NO.:

A-4

REVISION DATE:
01-27-2021
SCALE: NTS
DESIGN BY:
PLL
CHECKED BY:
JCD


BLDG. CODE:

SG

RECORD FLOOR PLAN
SEA GULL SQUARE

FOURTH FLOOR PLAN

SALISBURY UNIVERSITY
FACILITIES PLANNING & CAPITAL PROJECTS
ARCHITECTURAL AND ENGINEERING SERVICES
1101 CAMDEN AVENUE
SALISBURY, MARYLAND 21801
410 - 543 - 6215

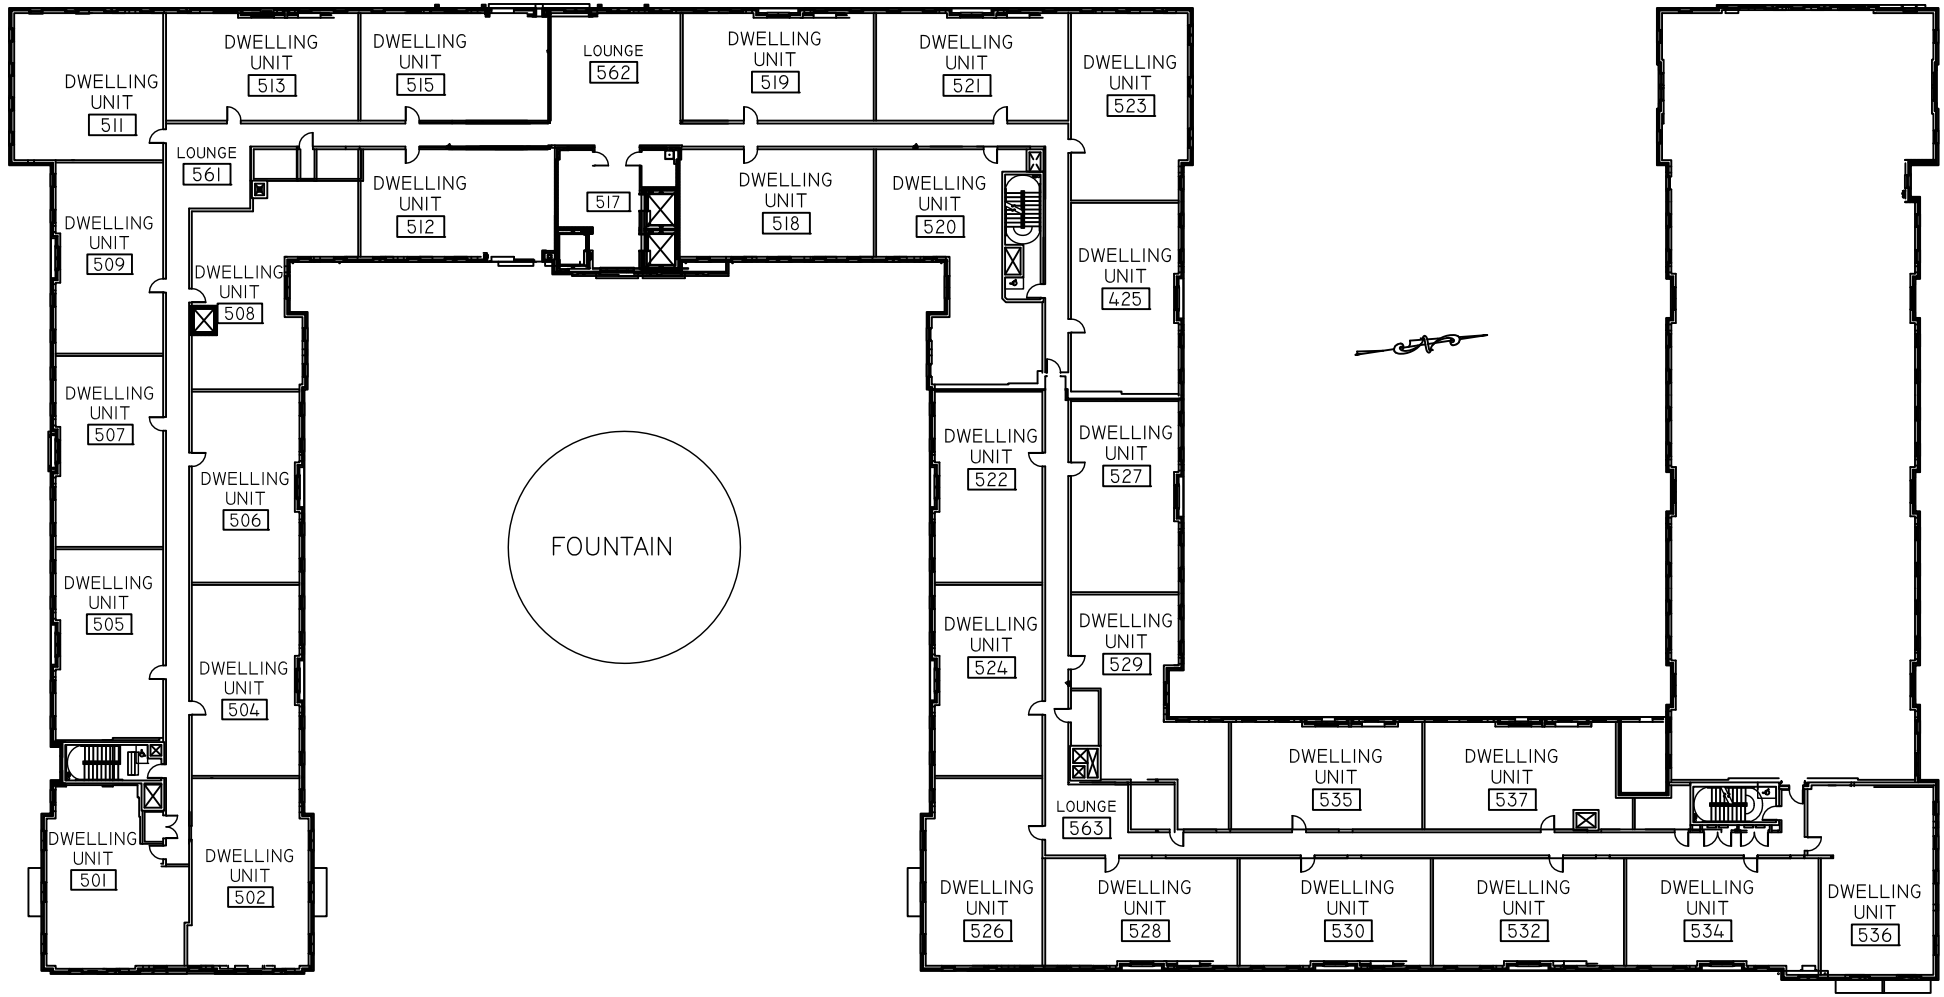

DWG. NO.:	REVISION DATE:
A-5	08-22-2018
BLDG. CODE:	SCALE:
SG	NTS
	DESIGN BY:
	PLA
	CHECKED BY:
	JCD

RECORD FLOOR PLAN
SEA GULL SQUARE

FIFTH FLOOR PLAN

SALISBURY UNIVERSITY
 FACILITIES PLANNING & CAPITAL PROJECTS
 ARCHITECTURAL AND ENGINEERING SERVICES
 1101 CAMDEN AVENUE
 SALISBURY, MARYLAND 21801
 410 - 543 - 6215